



Breakroom & Restroom Reflected Ceiling Plan
1/4" = 1'-0"

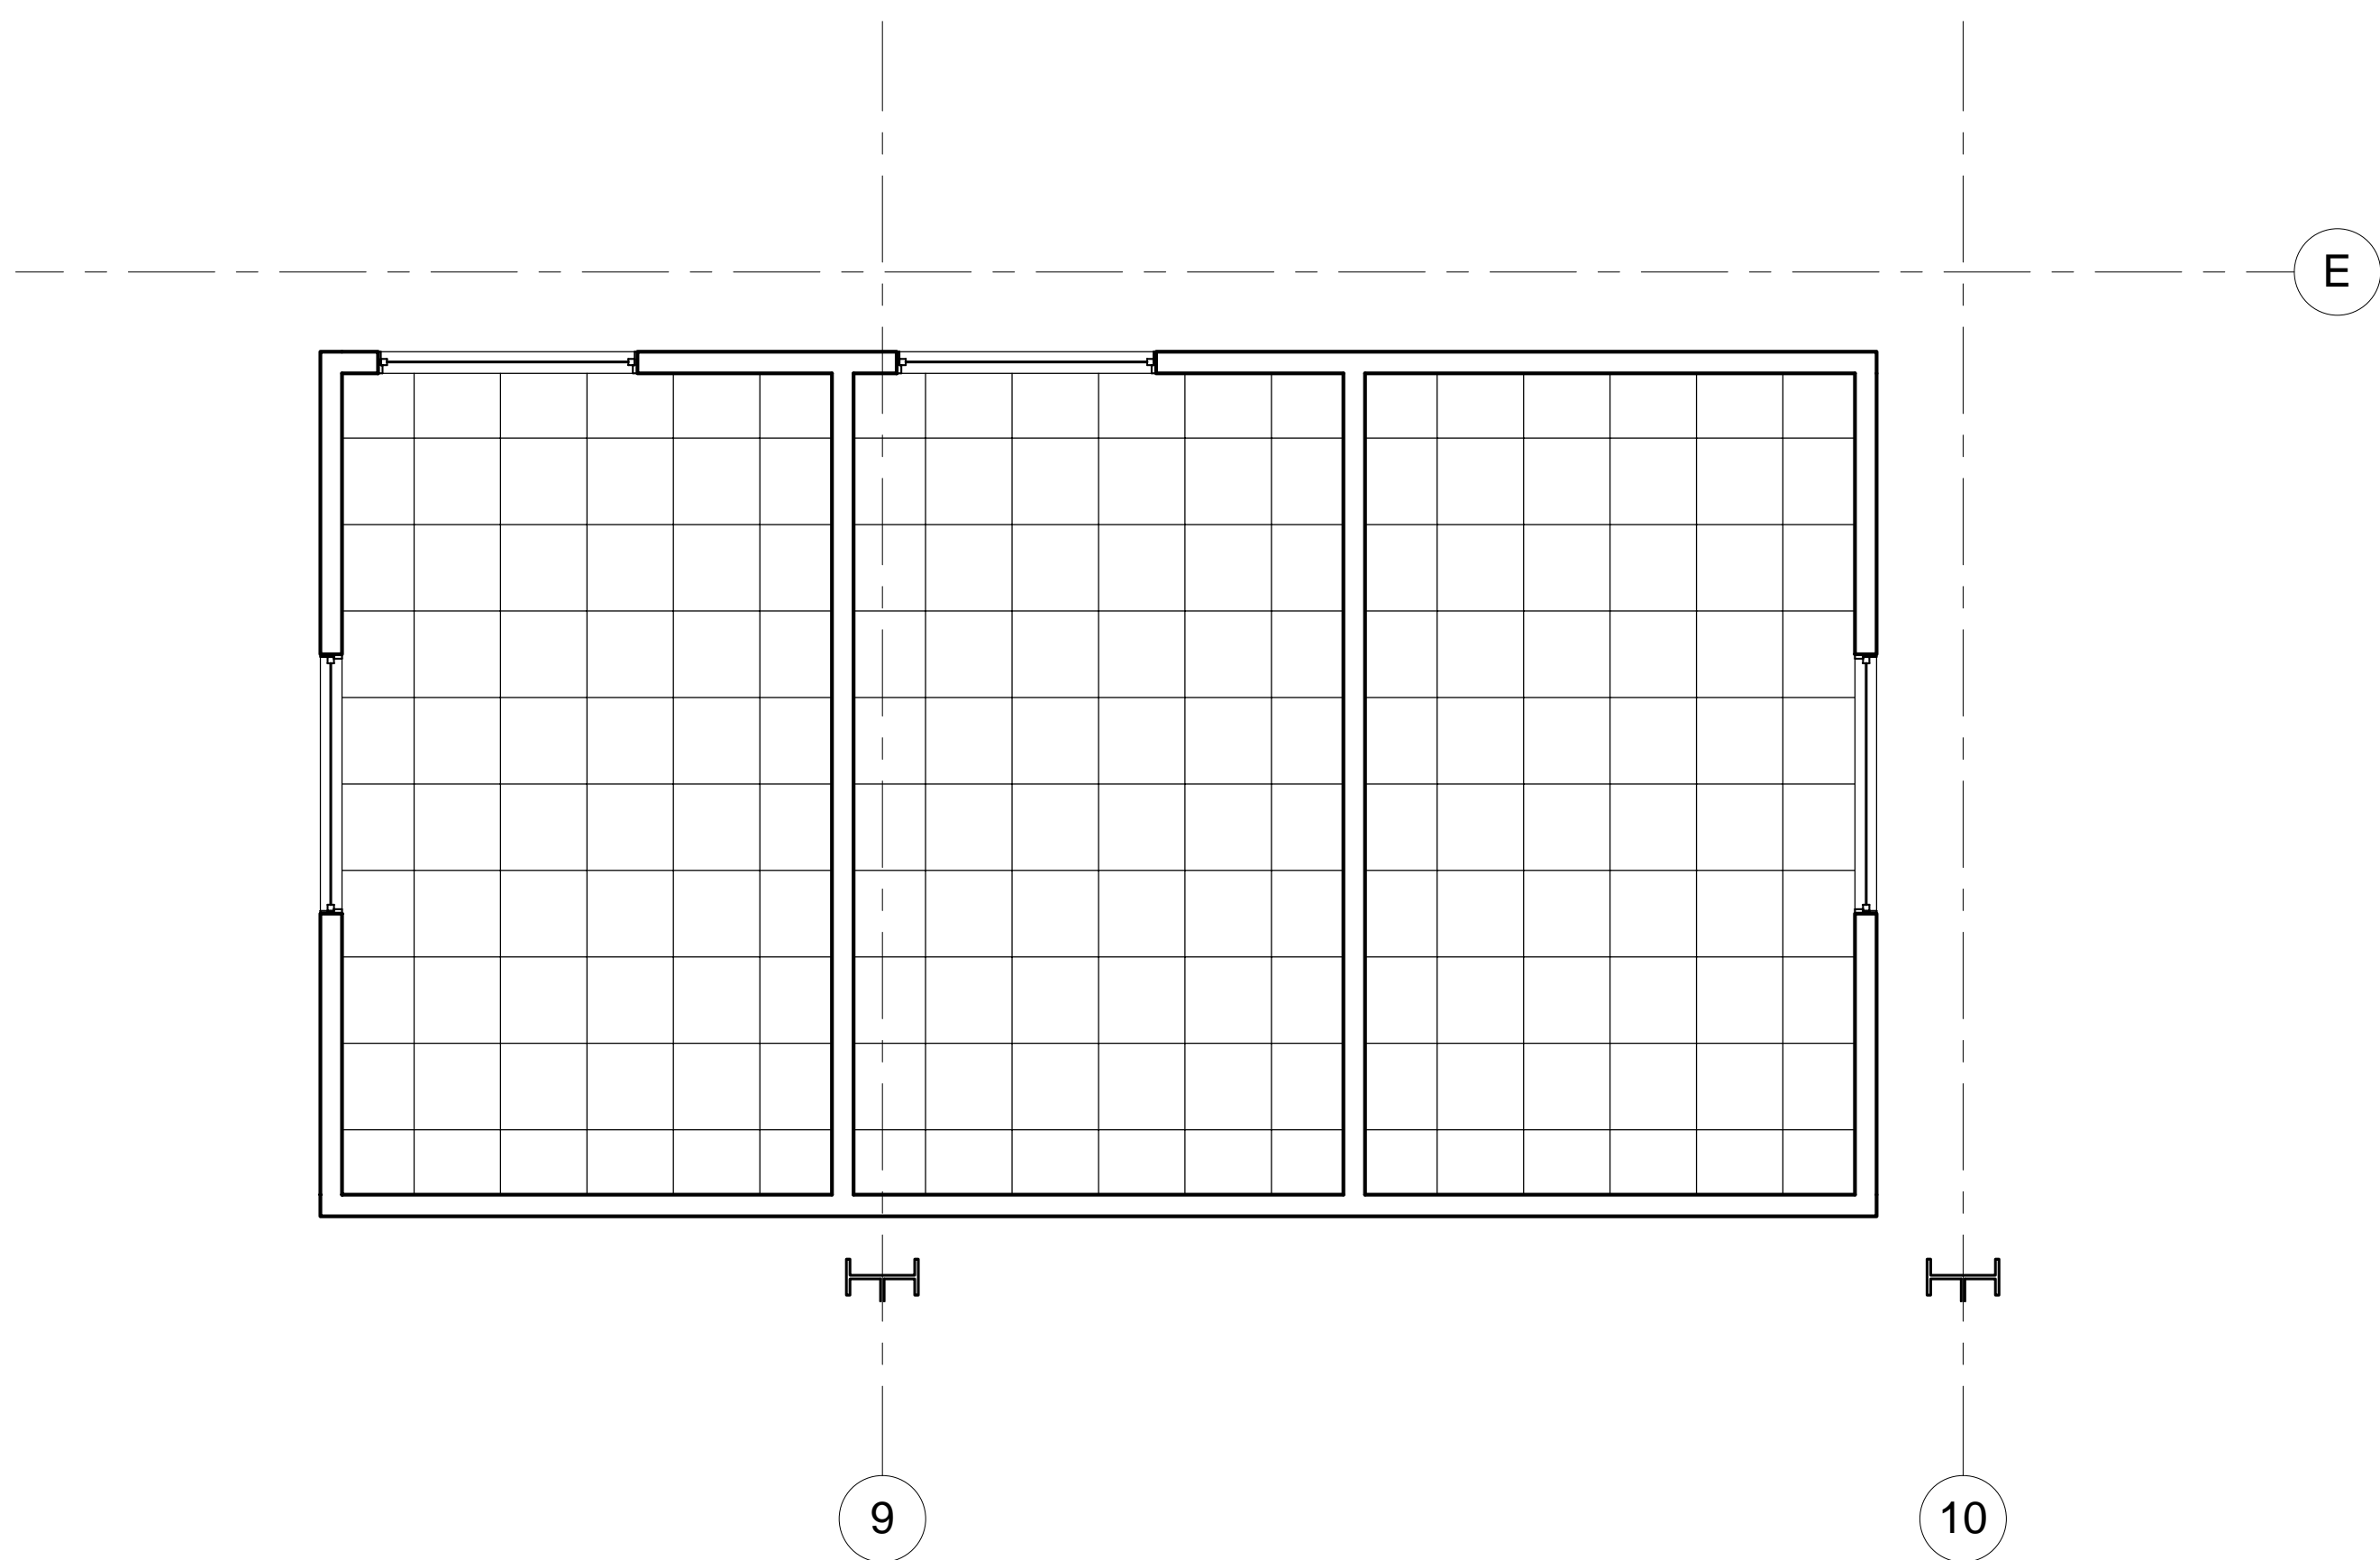

Offices Reflected Ceiling Plan
1/4" = 1'-0"

4/15/2010 8:08:25 AM

Reflected Ceiling Plan	
Project number	2010-001
Date	2/16/10
Drawn by	Author
Checked by	Checker
A1.3	
Scale	1/4" = 1'-0"

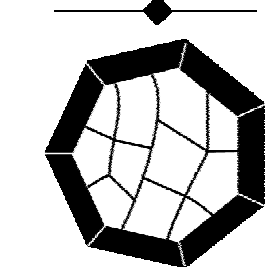

SEPTAGON
CONSTRUCTION
113 East Third Street Sedalia, MO 65301
660-827-2925 FAX 660-426-8058
www.septagon.com

ProEnergy Aero
Refurbish Bldg.
Sedalia, Missouri

Signature Must Be in Red

No.	Date	Description	By