




Plant B

115KV Line

Plant A

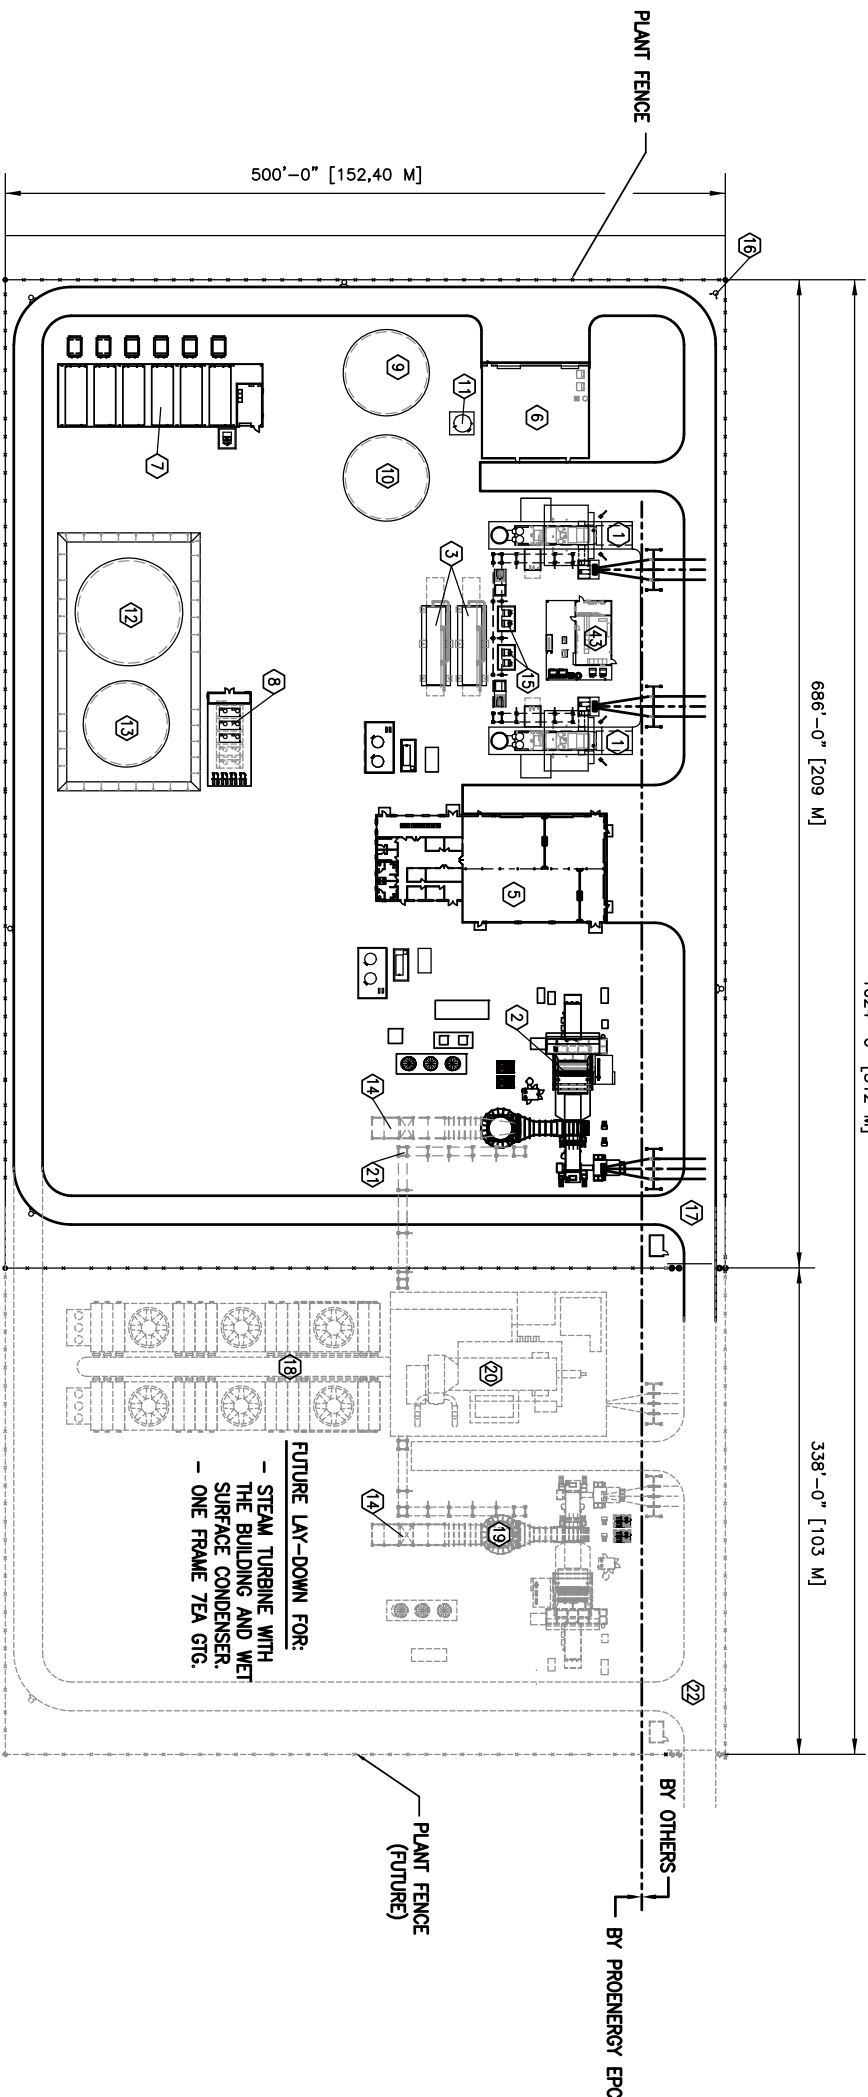

-
- 0 20' 40' 60' 80' 100' 200'

REVISIONS		CUSTOMER INFORMATION		© COPYRIGHT, 2008, ProEnergy SERVICES ALL RIGHTS RESERVED. THIS DRAWING IS THE PROPRIETARY AND/OR CONFIDENTIAL PROPERTY OF ProEnergy SERVICES AND IS LOANED IN STRICT CONFIDENCE WITH THE UNDERSTANDING THAT IT WILL NOT BE REPRODUCED OR TRANSMITTED IN ANY FORM OR BY ANY MEANS, ELECTRONIC OR MECHANICAL, INCLUDING PHOTOCOPYING, RECORDING, OR BY ANY INFORMATION STORAGE AND RETRIEVAL SYSTEM. IT SHALL BE IMMEDIATELY RETURNED ON DEMAND, AND IS SUBJECT TO ALL OTHER TERMS AND CONDITIONS OF ANY WRITTEN AGREEMENT OR PURCHASE ORDER WHICH INCORPORATES OR RELATES TO THIS DRAWING.	
		DERWICK ASSOCIATES S.A.			
		DERWICK			
		NO.		DATE	
		BY		APPROD	
		DESCRIPTION			
		REVISIONS			
		SCALE		1"=60'	
		SIZE		D	
		DRAWN		SL	
		CHECK		01/20/10	
		DESIGN			
		PROJ ENGR			
		PROJ MGR			
		QA MGR			
		SCALE		1"=60'	
		SIZE		D	
		DRAWN		SL	
		CHECK		01/20/10	
		DESIGN			
		PROJ ENGR			
		PROJ MGR			
		QA MGR			
		SCALE		1"=60'	
		SIZE		D	
		DRAWN		SL	
		CHECK		01/20/10	
		DESIGN			
		PROJ ENGR			
		PROJ MGR			
		QA MGR			
		SCALE		1"=60'	
		SIZE		D	
		DRAWN		SL	
		CHECK		01/20/10	
		DESIGN			
		PROJ ENGR			
		PROJ MGR			
		QA MGR			
		SCALE		1"=60'	
		SIZE		D	
		DRAWN		SL	
		CHECK		01/20/10	
		DESIGN			
		PROJ ENGR			
		PROJ MGR			
		QA MGR			
		SCALE		1"=60'	
		SIZE		D	
		DRAWN		SL	
		CHECK		01/20/10	
		DESIGN			
		PROJ ENGR			
		PROJ MGR			
		QA MGR			
		SCALE		1"=60'	
		SIZE		D	
		DRAWN		SL	
		CHECK		01/20/10	
		DESIGN			
		PROJ ENGR			
		PROJ MGR			
		QA MGR			
		SCALE		1"=60'	
		SIZE		D	
		DRAWN		SL	
		CHECK		01/20/10	
		DESIGN			
		PROJ ENGR			
		PROJ MGR			
		QA MGR			
		SCALE		1"=60'	
		SIZE		D	
		DRAWN		SL	
		CHECK		01/20/10	
		DESIGN			
		PROJ ENGR			
		PROJ MGR			
		QA MGR			
		SCALE		1"=60'	
		SIZE		D	
		DRAWN		SL	
		CHECK		01/20/10	
		DESIGN			
		PROJ ENGR			
		PROJ MGR			
		QA MGR			
		SCALE		1"=60'	
		SIZE		D	
		DRAWN		SL	
		CHECK		01/20/10	
		DESIGN			
		PROJ ENGR			
		PROJ MGR			
		QA MGR			
		SCALE		1"=60'	
		SIZE		D	
		DRAWN		SL	
		CHECK		01/20/10	
		DESIGN			
		PROJ ENGR			
		PROJ MGR			
		QA MGR			
		SCALE		1"=60'	
		SIZE		D	
		DRAWN		SL	
		CHECK		01/20/10	
		DESIGN			
		PROJ ENGR			
		PROJ MGR			
		QA MGR			
		SCALE		1"=60'	
		SIZE		D	
		DRAWN		SL	
		CHECK		01/20/10	
		DESIGN			
		PROJ ENGR			
		PROJ MGR			
		QA MGR			
		SCALE		1"=60'	
		SIZE		D	
		DRAWN		SL	
		CHECK		01/20/10	
		DESIGN			
		PROJ ENGR			
		PROJ MGR			
		QA MGR			
		SCALE		1"=60'	
		SIZE			

ProEnergy EPC Services, LLC			
GENERAL ARRANGEMENT PLOT PLAN			
LM-5000 & (1) FRAME 7EA			
CVG POWER PLANT A			
(2)			
SIGNATURE	DWG NO.	SH NO.	REVISION
TT001	1001-10-001	1	A