


EARTH NORTH

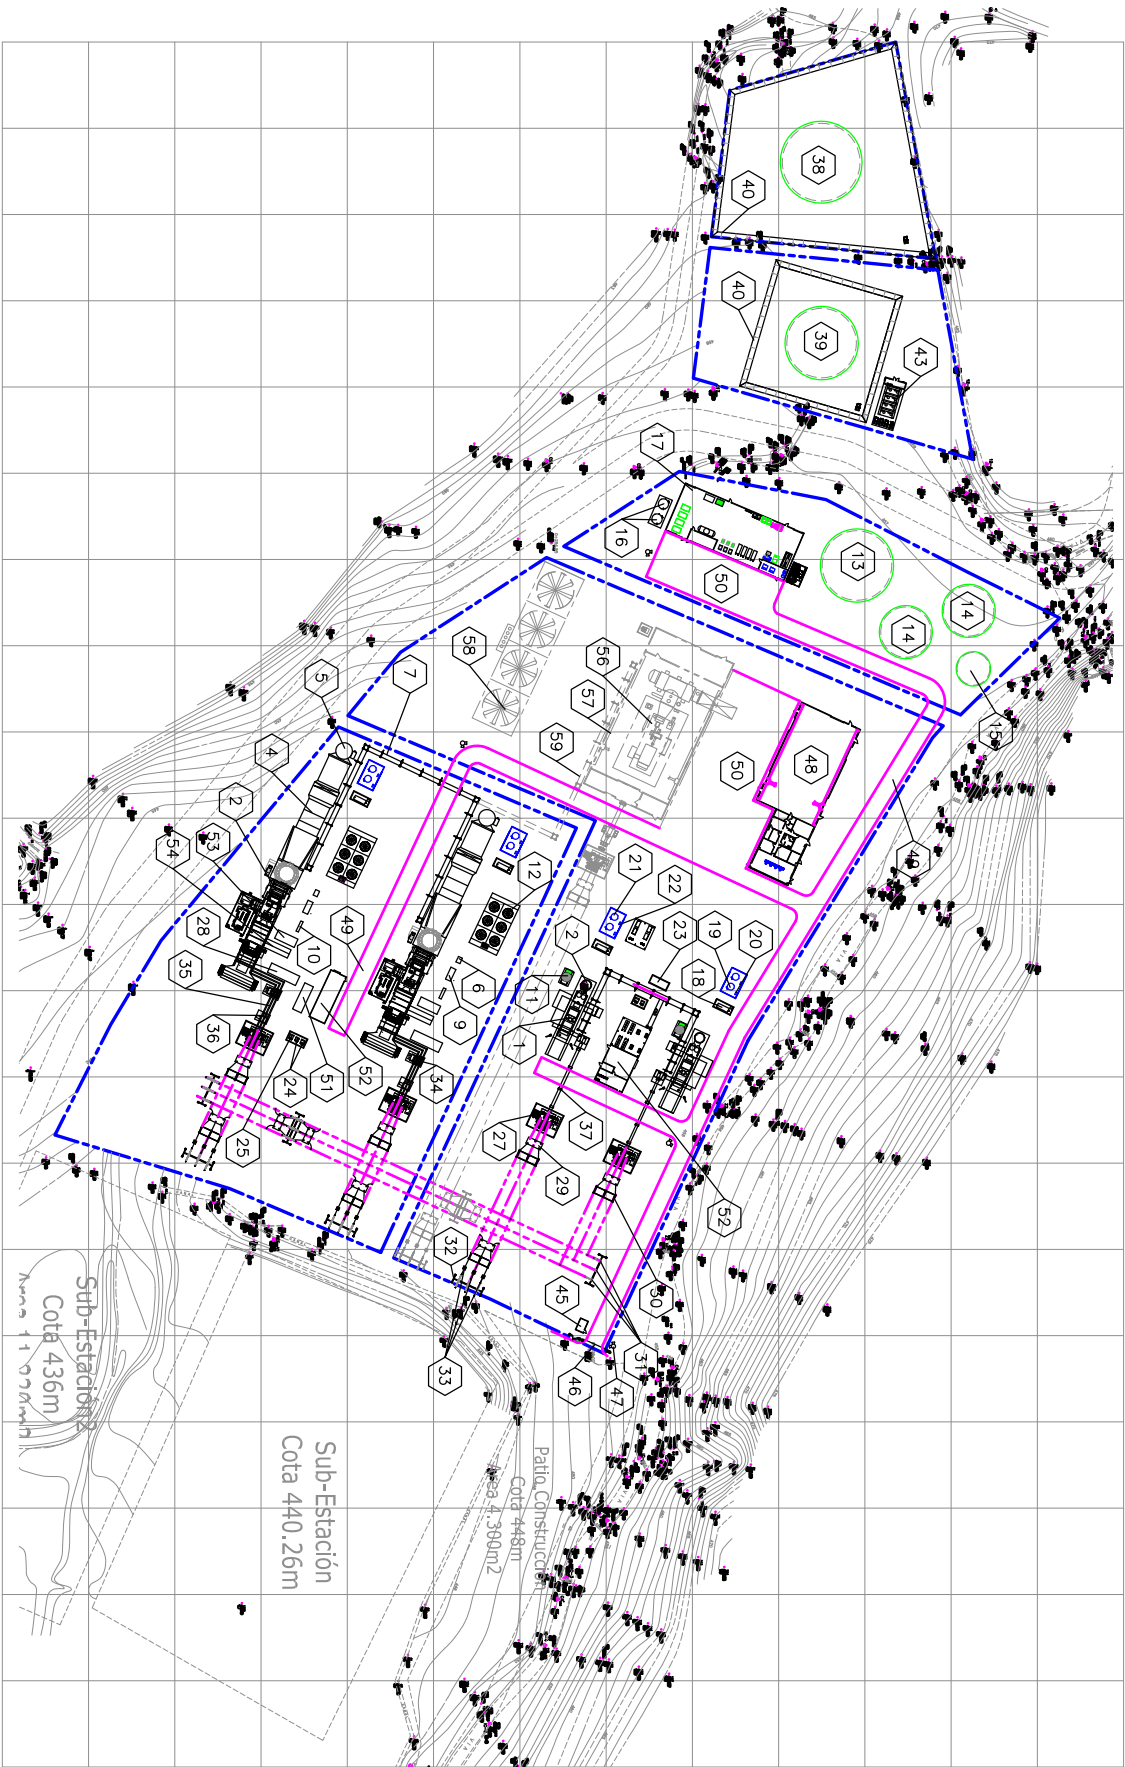

LEGEND:

PRIME MOVERS AND ASSOCIATE EQUIPMENT

- 1 G.E. LM-6000 GAS TURBINE GENERATOR.
- 2 LM-6000 EXHAUST STACK.
- 3 G.E. FRAME 7FA GAS TURBINE GENERATOR.
- 4 FRAME 7FA HRSG.
- 5 FRAME 7FA EXHAUST STACK.
- 6 EVAP COOLING SKID.
- 7 PIPE RACK.

WATER TREATMENT

- 8 LM-6000 PUMPS SHED.
- 9 WASH WATER SKID.
- 10 CO2 FIRE SKID.
- 11 GTG OIL COOLER SKID FOR LM-6000.
- 12 L.O. FIN FAN COOLER SKID FOR FRAME 7FA.
- 13 RAW/FIRE WATER TANK (1,000,000 GALS).
- 14 DEMIN WATER TANK (660,000 GALS EACH).
- 15 EVAP WATER TANK (300,000 GALS).
- 16 R.O. WATER TANKS.
- 17 WATER TREATMENT BUILDING:
 - WATER TREATMENT PUMPS.
 - RAW WATER FORWARDING PUMPS.
 - EVAP WATER FORWARDING PUMPS.
 - INSTRUMENT AIR COMPRESSOR PACKAGE.
 - FIRE WATER PUMPS.
 - FOAM SYSTEMS.

WASTE AREA

- 18 OILY WATER SEPARATOR.
- 19 WASTE OIL TANK.
- 20 WASTE OIL PUMP.
- 21 WASTE WATER TANK.
- 22 WASTE WATER PUMP.

ELECTRICAL EQUIPMENT

- 23 BLACK START GENERATOR.
- 24 AUXILIARY TRANS FORMER (4160 V).
- 25 AUXILIARY TRANSFORMER (480 V).
- 26 CONTROL ENCLOSURE (LOCATED IN WATER TREATMENT BUILDING).
- 27 STEP-UP TRANSFORMER.
- 28 PECC BUILDING.
- 29 SFG BREAKER.
- 30 DISCONNECT SWITCH.
- 31 LIGHTNING ARRESTER.


- 32 DEAD END TOWER.
- 33 POTENTIAL TRANSFORMER (TYPE CVT).
- 34 AUXILIARY TRANSFORMER (10 MVA FOR FRAME 7FA).
- 35 ISO PHASE BUS.
- 36 15 KV SWITCHGEAR.
- 37 OVERHEAD CABLE TRAY (FOR LM-6000).


LIQUID FUEL TREATMENT

- 38 RAW FUEL TANK (2,000,000 GALS).
- 39 TREATED FUEL TANK (1,000,000 GALS).
- 40 FUEL TANK DIKE.
- 41 LIQUID FUEL FORWARDING PUMPS.
- 42 TREATED FUEL FORWARDING PUMPS.
- 43 CENTRIFUGE PACKAGE.
- 44 CENTRIFUGE FORWARDING PUMPS.

MISCELLANEOUS

- 45 GUARD HOUSE.
 - 46 GATE.
 - 47 FLOOD LIGHTING POLE.
 - 48 OFFICE/CONTROL/WAREHOUSE BUILDING WITH OVERHEAD CRANE.
 - 49 ROAD.
 - 50 SERVICE AND PARKING AREA.
 - 51 LCI BUILDING.
 - 52 UTILITY BUILDING.
 - 53 LIQUID FUEL/ATOMIZING MODULE.
 - 54 ACCESSORY MODULE.
 - 55 LIQUID FUEL OFF LOAD PUMPS.
- FUTURE EQUIPMENT FOR COMBINED CYCLE PLANT**
- 56 STEAM TURBINE GENERATOR.
 - 57 STEAM TURBINE BUILDING.
 - 58 COOLING TOWER PACKAGE.
 - 59 PIPE RACK.

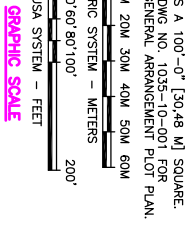

CUSTOMER INFORMATION										REVISED
© COPYRIGHT, 2008, ProEnergy Services All Rights Reserved. THIS DRAWING IS THE PROPRIETARY AND/OR CONFIDENTIAL PROPERTY OF ProEnergy Services AND IS LOANED IN STRICT CONFIDENCE WITH THE UNDERSTANDING THAT IT WILL NOT BE REPRODUCED, COPIED, OR TRANSMITTED IN ANY MANNER WITHOUT THE WRITTEN CONSENT OF PROENERGY SERVICES. IT SHALL BE IMMEDIATELY RETURNED ON DEMAND, AND IS SUBJECT TO ALL OTHER TERMS AND CONDITIONS OF ANY WRITTEN AGREEMENT OR PURCHASE ORDER WHICH INCORPORATES OR RELATES TO THIS DRAWING.										
NO.	DATE	BY	APP'D	DESCRIPTION	REVISIONS	SCALE	SIZE	D	11/03/10	
						1"=60'				
<div>ProEnergy EPC SERVICES</div> <div>907 SOUTH DETROIT AVE SUITE 1040 TULSA, OKLAHOMA 74120 OFFICE FAX www.proenergyservices.com</div>										
<div>ProEnergy EPC Services, LLC GENERAL ARRANGMENT PLOT PLAN TWO 7FA & TWO LM-6000 GIG UNITS CURUPAO POWER PLANT</div> <div>CURUPAO JOB NO. 110325 DWG NO. 10325-10-002 SH NO. - REV A VENEZUELA</div>										