


480 V, 1200 A, 3 ϕ , 3 W, 60 HZ

GTG100-MCC1E-AC – PART OF G.E. PACKAGE GTG-100 (UNIT FOR GTG-200 IS SIMILAR) *


15 KVA
480/240/120 V
-1 PH

5 A
MC-1A

120/240 V, 225 A, 1 PH, 60 HZ PANEL BOARD

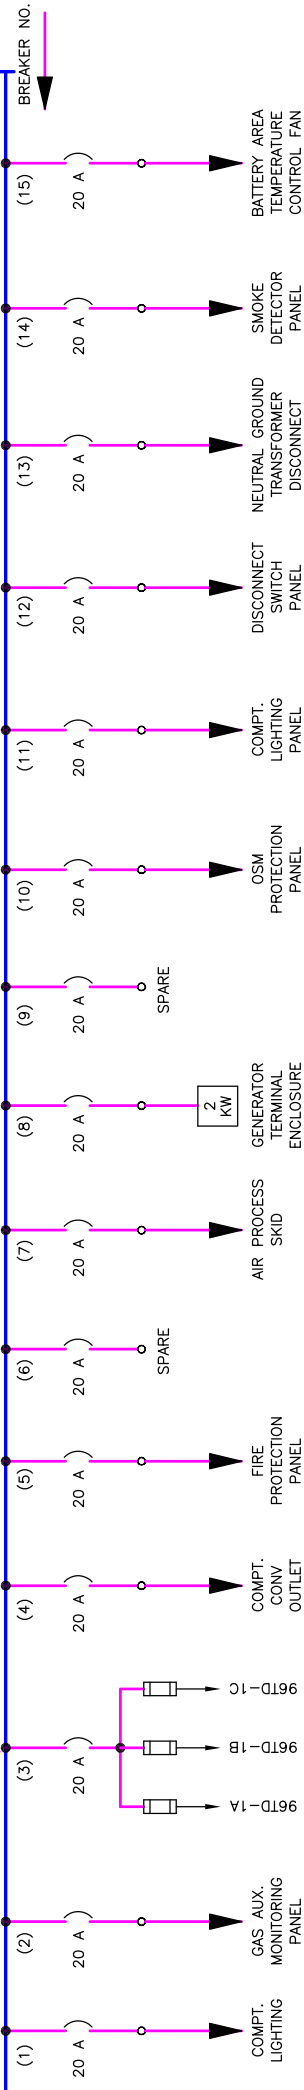


120/240 V, 225 A, 1 PH, 60 HZ PANEL BOARD

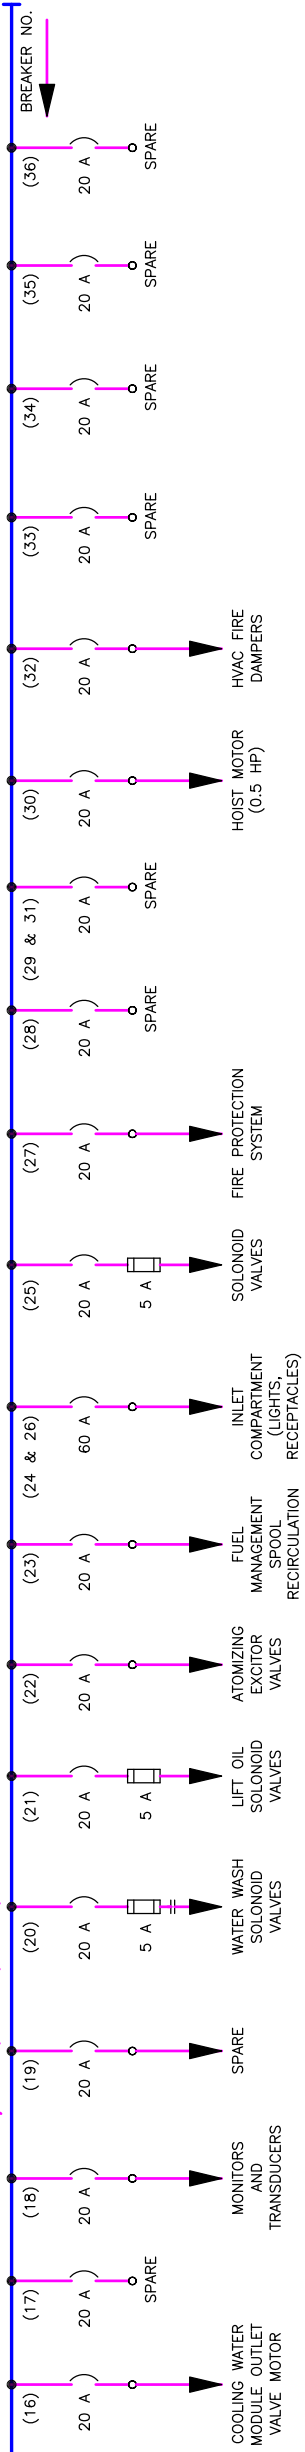


480 V, 1200 A, 3 ϕ , 3 W, 60 HZ

GTG100-MCC1E-AC – PART OF G.E. PACKAGE GTG-100 (UNIT FOR GTG-200 IS SIMILAR) *

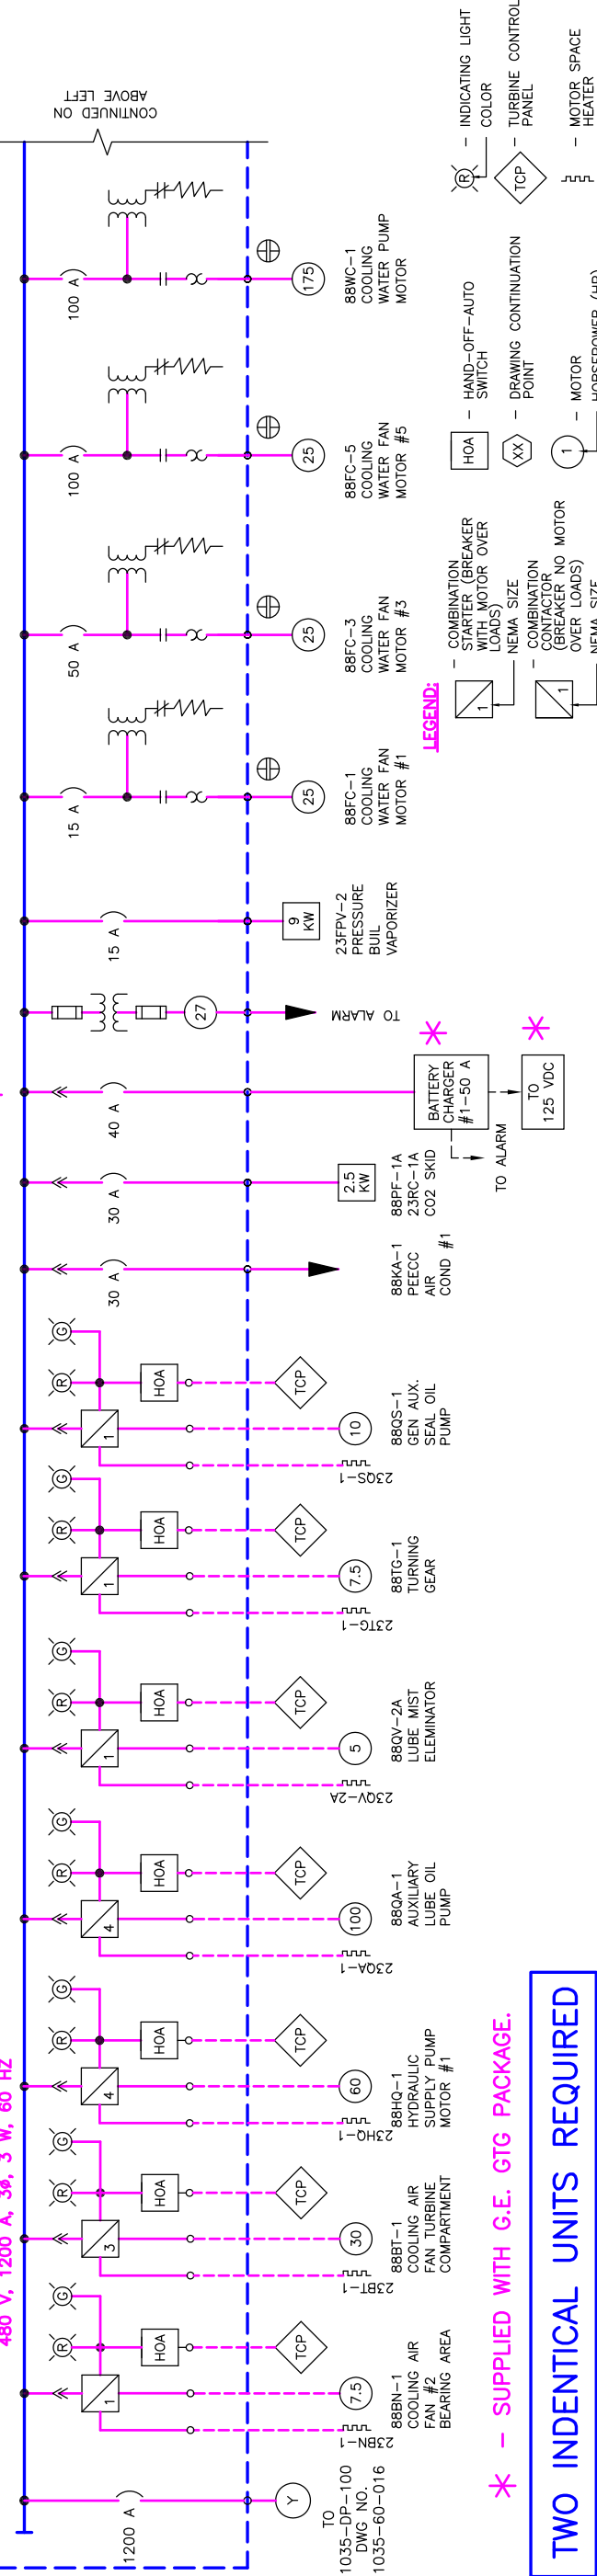

* - SUPPLIED WITH G.E. GTG PACKAGE.

TWO IDENTICAL UNITS REQUIRED

REVISED										CUSTOMER INFORMATION																			
<p>© COPYRIGHT, 2008, ProEnergy Services. ALL RIGHTS, RESERVED</p> <p>THIS DRAWING IS THE PROPRIETARY AND/OR CONFIDENTIAL PROPERTY OF ProEnergy Services AND IS LOANED IN STRICT CONFIDENCE WITH THE UNDERSTANDING THAT IT WILL NOT BE REPRODUCED, COPIED, OR USED FOR ANY PURPOSE WITHOUT THE WRITTEN CONSENT OF ProEnergy Services. IT SHALL BE IMMEDIATELY RETURNED ON DEMAND, AND IS SUBJECT TO ALL OTHER TERMS AND CONDITIONS OF ANY WRITTEN AGREEMENT OR PURCHASE ORDER WHICH INCORPORATES OR RELATES TO THIS DRAWING.</p>																													
DRAWN		SL		10/08/10		CHECK																							
						DESIGN																							
						PROJ ENGR																							
						PROJ MGR																							
						QA MGR																							
NO.		DATE		BY		APP'D		DESCRIPTION		NONE		SIZE		D															
								REVISIONS																					
<div><div>ProEnergy EPC SERVICES</div></div>																													
907 SOUTH DETROIT AVE. SUITE 140 TULSA, OKLAHOMA 74120 OFFICE FAX www.proenergyservices.com																													
ProEnergy EPC Services, LLC										ONE LINE DIAGRAM—MCC1E—AC TWO 7FA & TWO LM-6000 GTG UNITS CURUPAO POWER PLANT																			
CURUPAO JOB. NO.										T1035										DWG. NO.		1035—60—016		REV		—		A	
VENEZUELA																													