


<u>REFERENCE DRAWINGS</u>	
00-004-1	STRUCTURAL GENERAL NOTES
00-004-2	STANDARD CONCRETE DETAILS
674224	GE PACKAGE POWER L.P. LM6000 INSTALLATION FOOTPRINT, ANCHOR BOLT AND SHEAR LUG LOCATION, REV. A, DATED 10/04/2001
9583-001	ATCO NOISE MANAGEMENT G.T. EXHAUST 1X LM6000 FOUNDATION PLAN AND LOADING TABLE, REV. A, DATED 03/20/2009

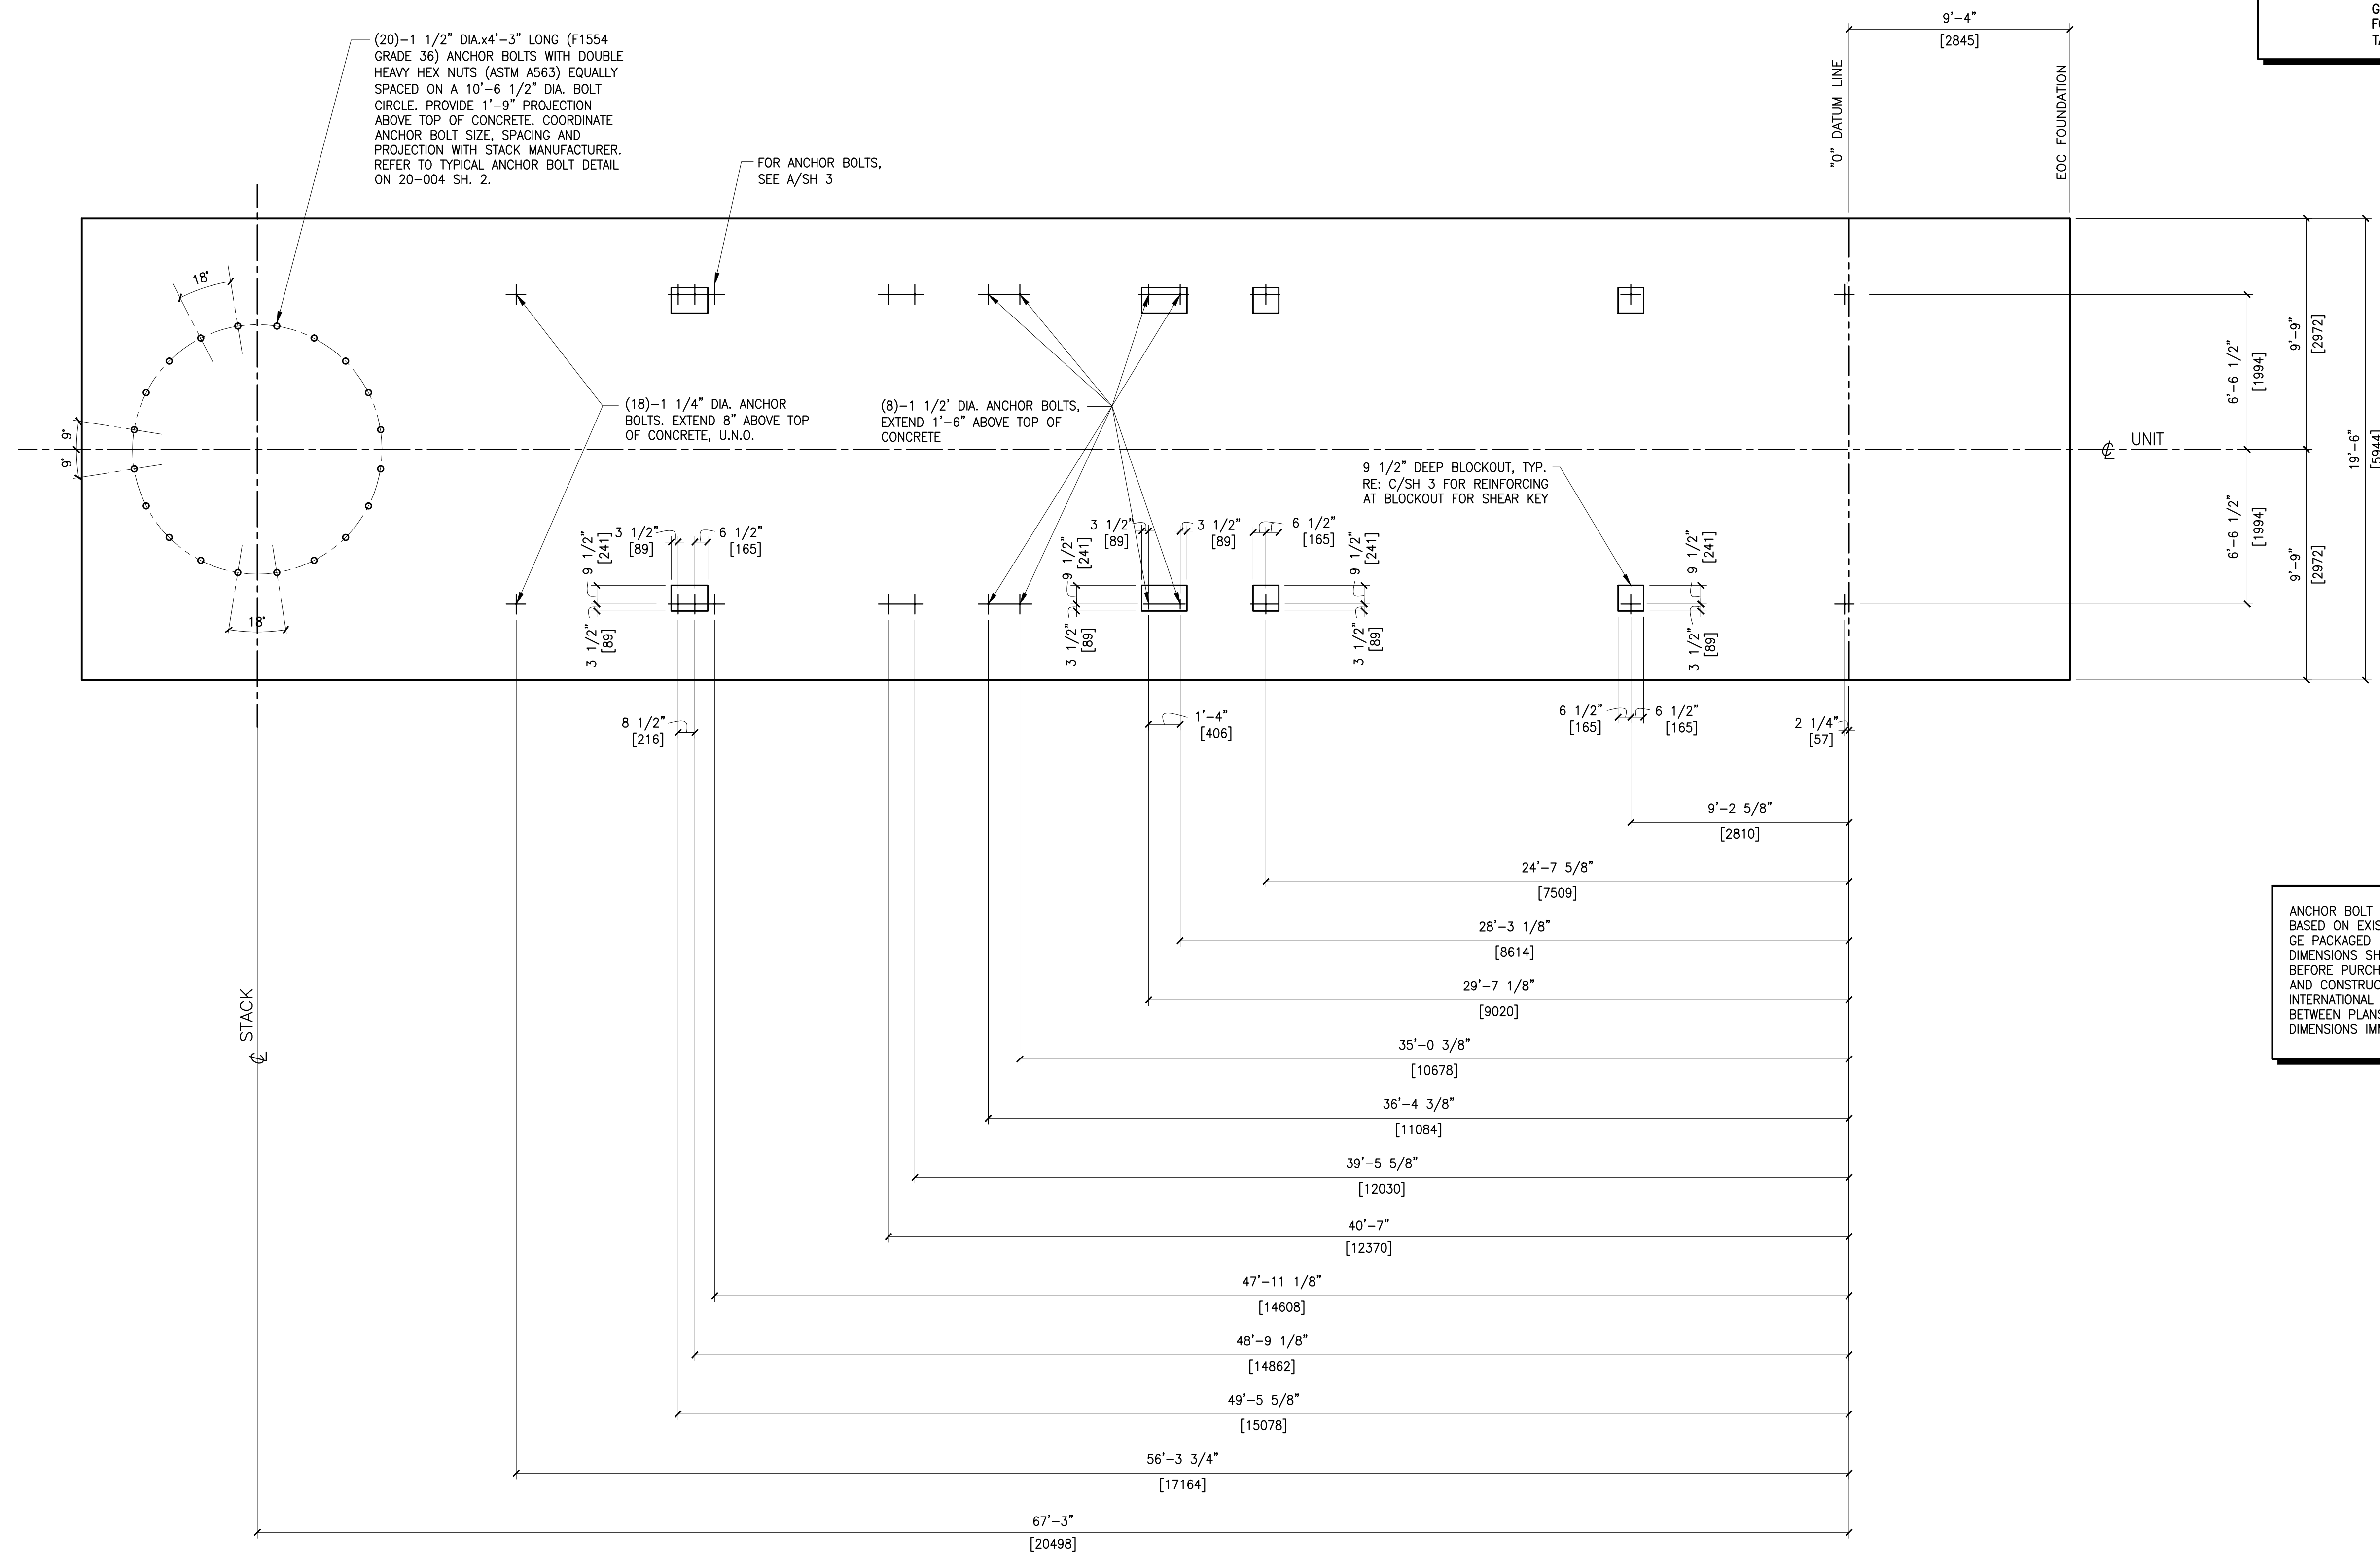

ANCHOR BOLT LOCATIONS ARE
BASED ON EXISTING DRAWINGS FROM
GE PACKAGED POWER. ALL
DIMENSIONS SHALL BE VERIFIED
BEFORE PURCHASE OF MATERIALS
AND CONSTRUCTION. NOTIFY EDG
INTERNATIONAL OF DISCREPANCIES
BETWEEN PLANS AND ACTUAL UNIT
DIMENSIONS IMMEDIATELY.

DISCLAIMER:
THIS DRAWING WAS PREPARED FOR USE ON A SPECIFIC SITE AT GUARENAS, VENEZUELA, CONTEMPORANEOUSLY WITH ITS ISSUE DATE AND IS NOT SUITABLE FOR USE ON A DIFFERENT PROJECT SITE OR AT A LATER TIME. REUSE OF THIS DRAWING OTHER THAN ACCORDING TO ITS INTENDED PURPOSE IS AT THE PROJECT OWNER'S SOLE RISK. MODIFICATIONS TO THE DRAWING MADE BY ANY OTHER PARTY WITHOUT THE WRITTEN CONSENT OF WALLACE ENGINEERING-STRUCTURAL CONSULTANTS, INC. AND EDG INTERNATIONAL, INC. IS AT THE PROJECT OWNER'S OWN RISK. USE OF THIS DRAWING FOR REFERENCE OR EXAMPLE ON ANOTHER PROJECT REQUIRES THE SERVICES OF PROFESSIONAL ARCHITECTS AND ENGINEERS. REPRODUCTION OF THIS DRAWING FOR REUSE ON ANOTHER PROJECT IS NOT AUTHORIZED, IS AT THE PROJECT OWNER'S RISK AND MAY BE CONTRARY TO THE LAW.

1 ANCHOR BOLT LOCATION PLAN - UNIT 100 (1 REQUIRED)

$$\overline{1/4'' = 1'-0''}$$


WALLACE ENGINEERING
STRUCTURAL CONSULTANTS
200 EAST BRADY STREET
TULSA, OKLAHOMA 74103-2012
918 584-5858
FAX 918 584-8689



EDGInternational, Inc
Certificate of Authorization No: 4913
Renewal Date: 6/30/2010



© COPYRIGHT, 2008, ProEnergy SERVICES ALL RIGHTS, RESERVED
THIS DRAWING IS THE PROPRIETARY AND/OR CONFIDENTIAL
PROPERTY OF ProEnergy SERVICES AND IS LOANED IN
STRICT CONFIDENCE WITH THE UNDERSTANDING THAT IT WILL
NOT BE REPRODUCED NOR USED FOR ANY PURPOSE EXCEPT
THAT FOR WHICH IT IS LOANED. IT SHALL BE IMMEDIATELY
RETURNED ON DEMAND, AND IS SUBJECT TO ALL OTHER TERMS
AND CONDITIONS OF ANY WRITTEN AGREEMENT OR PURCHASE
ORDER WHICH INCORPORATES OR RELATES TO THIS DRAWING.

D					
0	04/03/10	RKH	ML	ISSUE FOR REVIEW	
NO.	DATE	BY	APP'D	DESCRIPTION	
				REVISIONS	

DRAWN	RKH	04/03/1
CHECK	ML	04/03/1
DESIGN	ML	04/03/1
ENGINEER		
PROJ MGR		
QA MGR		
SCALE	AS NOTED	SIZE D



**907 S DETROIT
SUITE 1140
TULSA, OKLAHOMA 74120
OFFICE 660-829-5100
FAX 918-270-2939
www.proenergyservices.com**

ProEnergy EPC Services, LLC

ANCHOR BOLT LOCATION PLAN
TURBINE GENERATOR LM-6000 - UNIT 100
GUARENAS 1 POWER PLANT

GUARENAS			VENEZUELA
JOB. NO.	DWG. NO.	SH NO.	REV
0920	20-002	2	0