


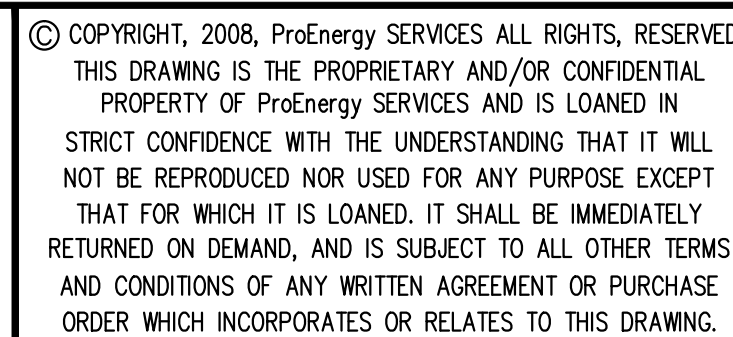


EDGInternational, Inc
Certificate of Authorization No: 4913
Renewal Date: 6/30/2010



0	04/10/10	RKH	ML	ISSUE FOR REVIEW	
NO.	DATE	BY	APP'D	DESCRIPTION	
				REVISIONS	



ProEnergy EPC Services, LLC				
ANCHOR BOLT LOCATION PLAN				
TURBINE GENERATOR LM 2500 - UNITS 200/300				
GUARENAS 1 POWER PLANT				
GUARENAS		VENEZUELA		
JOB. NO.	DWG NO.	SH NO.	REV	
0920	20-003	2	0	

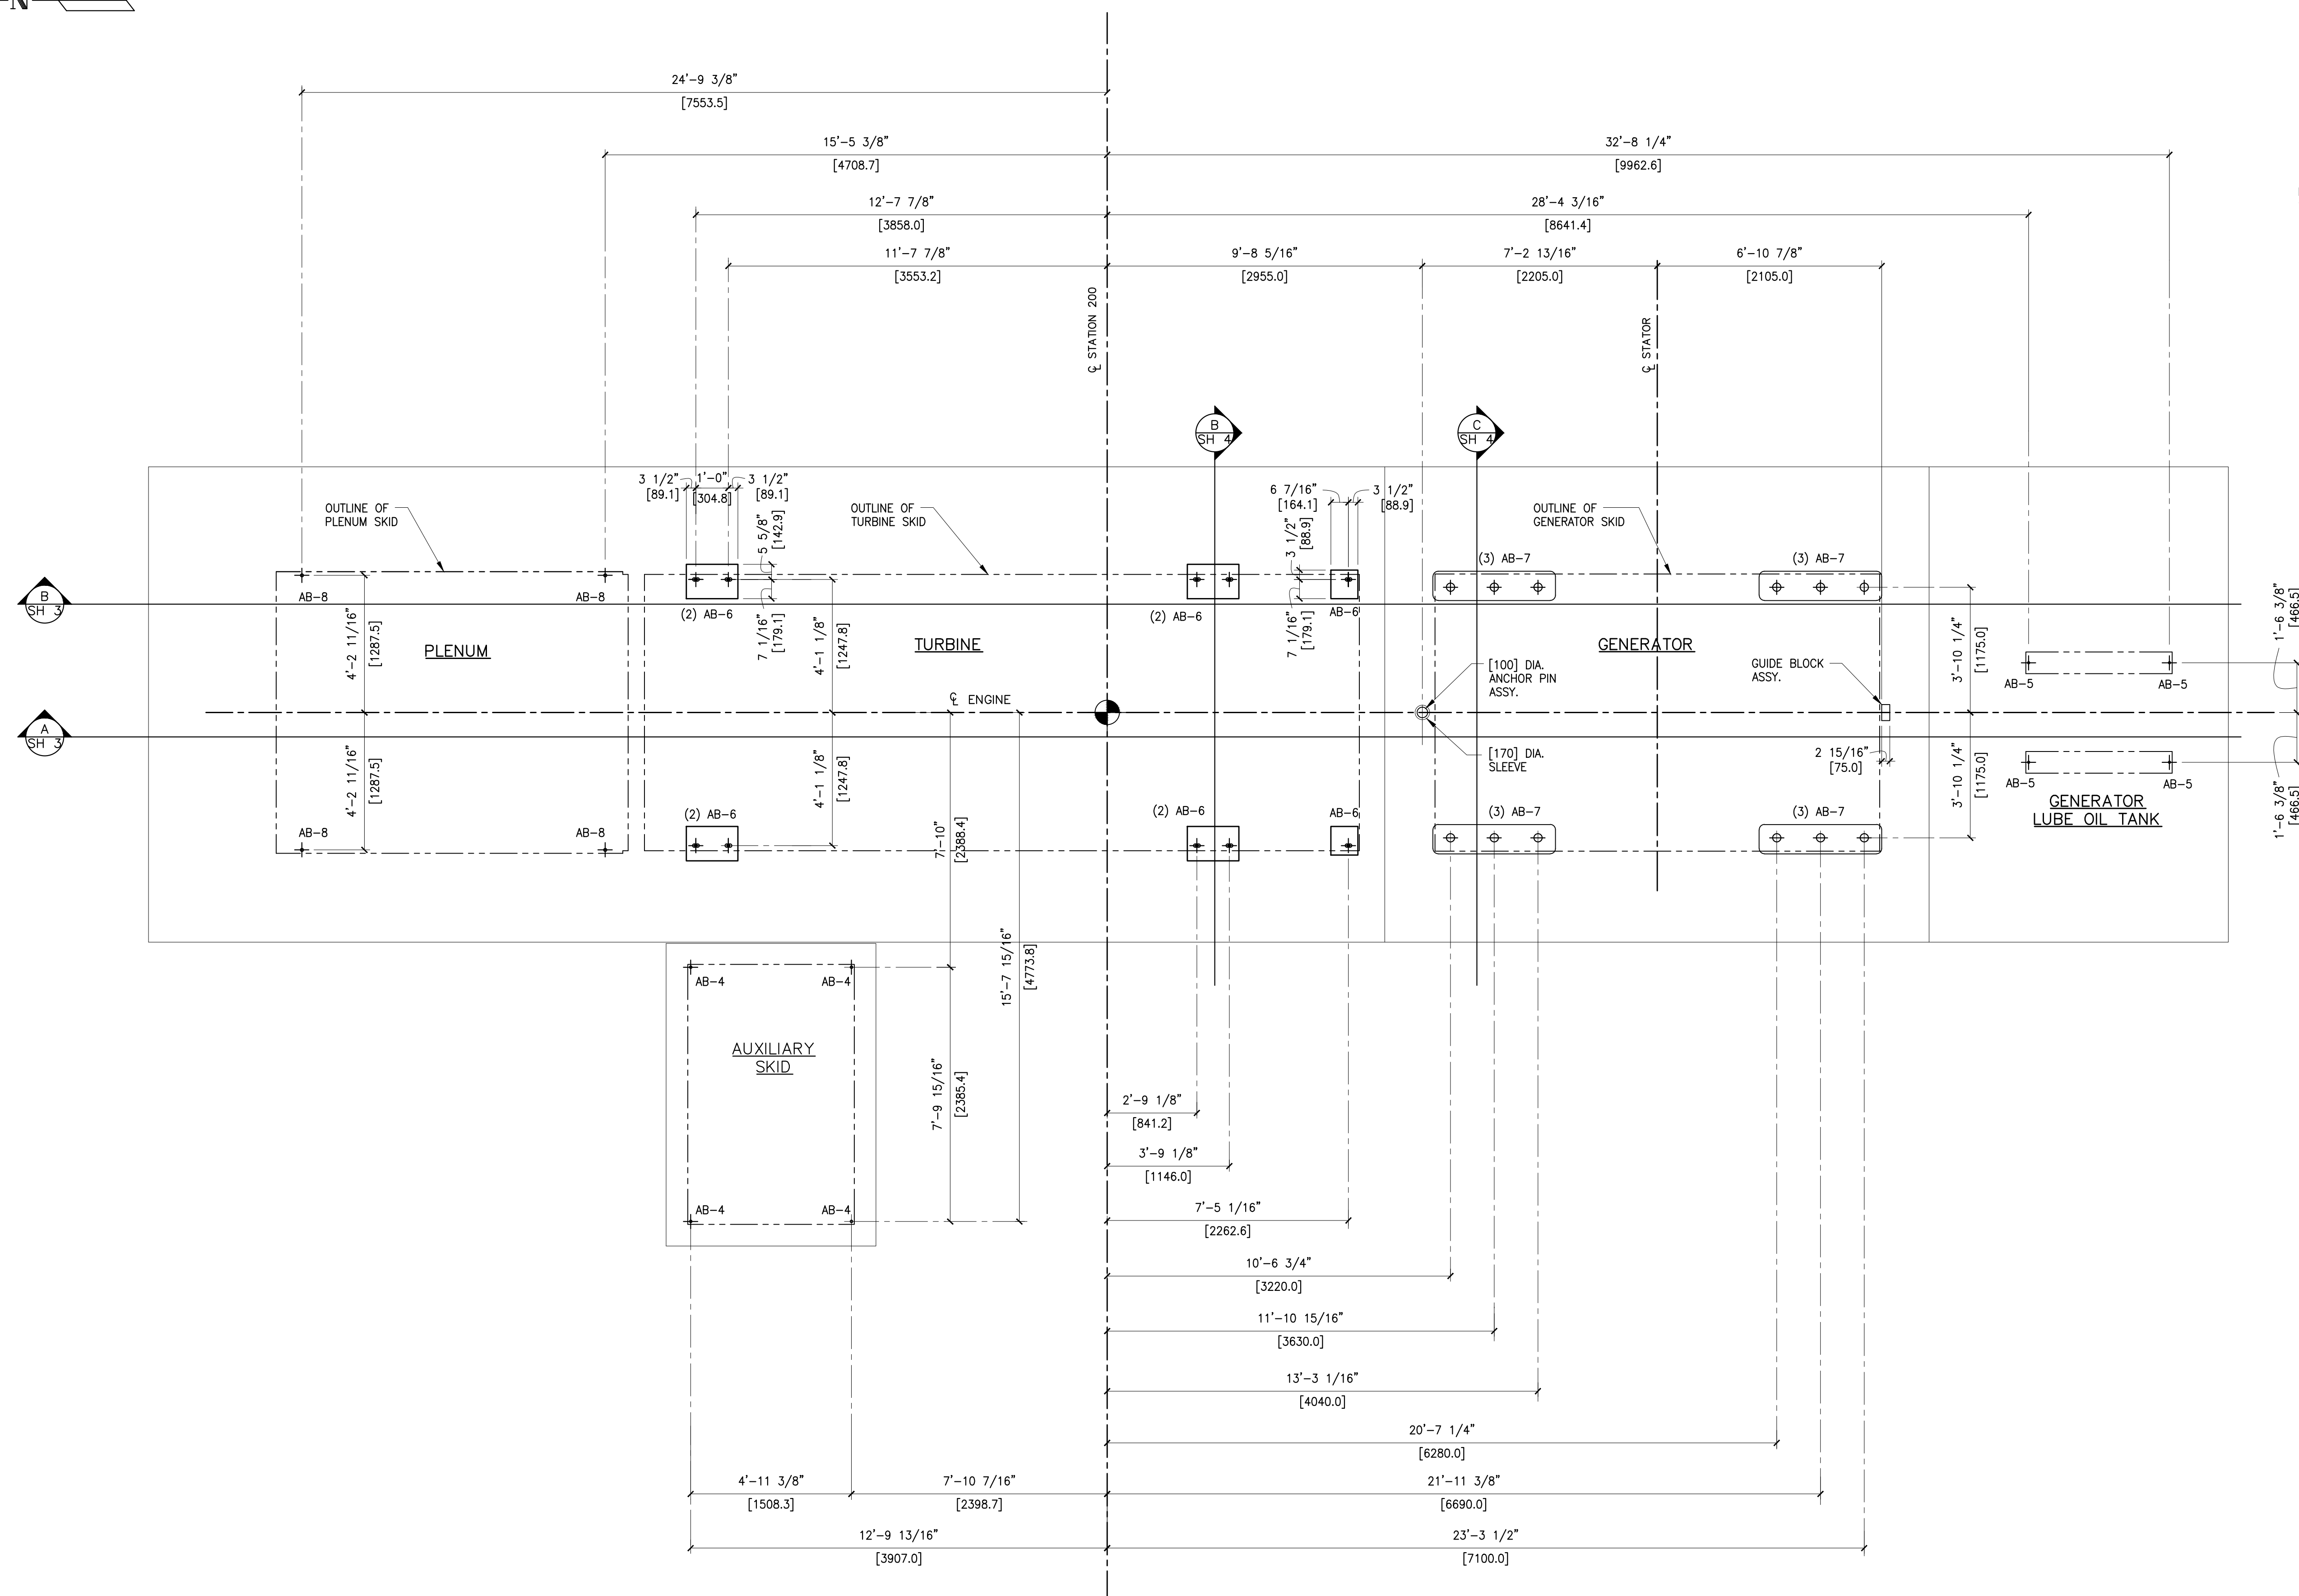

NOTES:
1. SEE SHEET 4 FOR ANCHOR BOLT SCHEDULE

DISCLAIMER:
THIS DRAWING WAS PREPARED FOR USE ON A SPECIFIC SITE AT GUARENAS,
VENEZUELA, CONTEMPORANEOUSLY WITH ITS ISSUE DATE AND IS NOT SUITABLE FOR
USE ON A DIFFERENT PROJECT SITE OR AT A LATER TIME. REUSE OF THIS DRAWING
OTHER THAN ACCORDING TO ITS INTENDED PURPOSE IS AT THE PROJECT OWNER'S
SOLE RESPONSIBILITY. THE DRAFTER'S PROHIBITED WITHOUT PRIOR WRITTEN
CONSENT OF WALLACE ENGINEERING-STRUCTURAL CONSULTANTS, INC. AND EDG
INTERNATIONAL, INC. IS AT THE PROJECT OWNER'S OWN RISK. USE OF THIS DRAWING
FOR REFERENCE OR EXAMPLE ON ANOTHER PROJECT REQUIRES THE SERVICES OF
PROPERLY LICENSED ARCHITECTS AND ENGINEERS. REPRODUCTION OF THIS DRAWING
FOR ANY OTHER PROJECT NOT AUTHORIZED, IS AT THE PROJECT OWNER'S
RISK AND MAY BE CONTRARY TO THE LAW.

1 TURBINE GENERATOR ANCHOR BOLTS LAYOUT (2 REQUIRED)
3/8" = 1'-0"