



A	RESERVED FOR ENGINEER'S SEAL		CUSTOMER INFORMATION		<p>© COPYRIGHT, 2008, PRO ENERGY SERVICES. ALL RIGHTS RESERVED. THIS DRAWING IS THE PROPRIETARY AND/OR CONFIDENTIAL PROPERTY OF PRO ENERGY SERVICES AND IS LOANED IN STRICT CONFIDENCE WITH THE UNDERSTANDING THAT IT WILL NOT BE REPRODUCED NOR USED FOR ANY PURPOSE EXCEPT THAT FOR WHICH IT IS LOANED. IT SHALL BE IMMEDIATELY RETURNED ON DEMAND, AND IS SUBJECT TO ALL OTHER TERMS AND CONDITIONS OF ANY WRITTEN AGREEMENT OR PURCHASE ORDER WHICH INCORPORATES OR RELATES TO THIS DRAWING.</p>							JOB NUMBER		ADDL. INFO	
												THIRD ANGLE PROJECTION		Energy Services, Inc. Houston, TX	
												UNLESS OTHERWISE SPECIFIED DIMENSIONS ARE IN INCHES DO NOT SCALE DRAWING		PRO ENERGY SERVICES 2031 ADAMS ROAD, SEDALIA, MISSOURI 65301 USA	
												TOLERANCES DECIMALS FRACTIONAL ANGULAR ± .03 ± .00 ± .00 ± .00		TITLE	
												NEXT ASSY.		DWG NO.	
												UNIT TYPE		REV.	
														ELE-002-01	
														SCALE	
														SHEET	
														OF	
8		7		6		5		4		3		2		1	

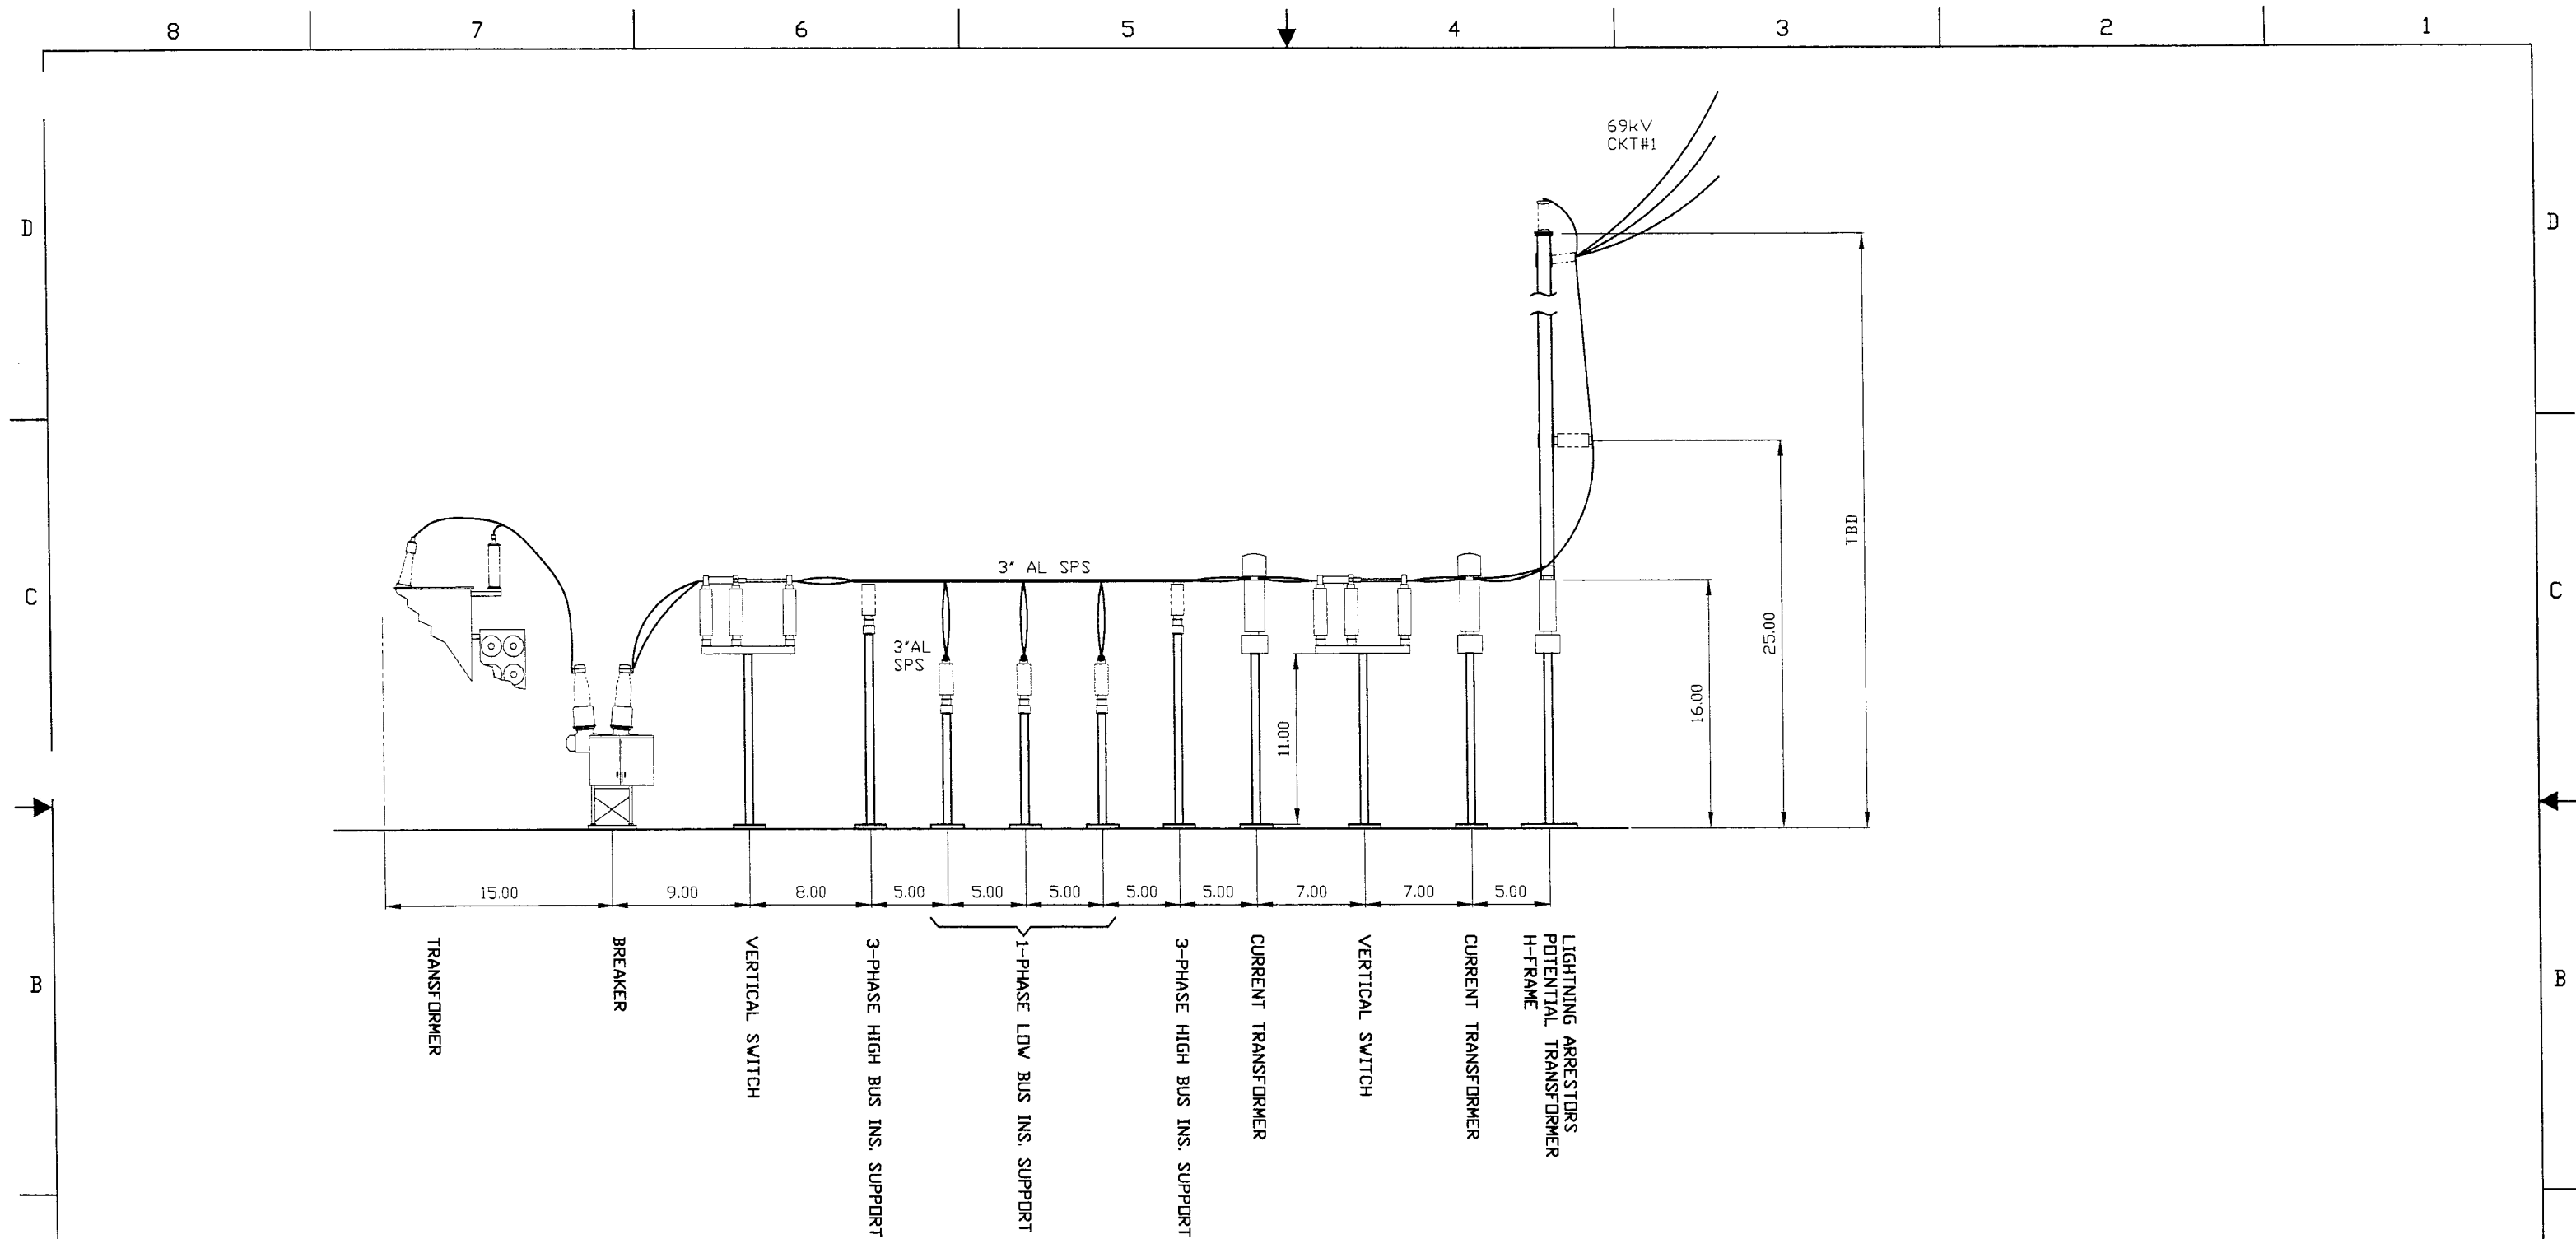

SECTION A-A

RESERVED FOR ENGINEER'S SEAL	CUSTOMER INFORMATION	<p>© COPYRIGHT, 2008, PRO ENERGY SERVICES. ALL RIGHTS RESERVED. THIS DRAWING IS THE PROPRIETARY AND/OR CONFIDENTIAL PROPERTY OF PRO ENERGY SERVICES AND IS LOANED IN STRICT CONFIDENCE WITH THE UNDERSTANDING THAT IT WILL NOT BE REPRODUCED NOR USED FOR ANY PURPOSE EXCEPT THAT FOR WHICH IT IS LOANED. IT SHALL BE IMMEDIATELY RETURNED ON DEMAND, AND IS SUBJECT TO ALL OTHER TERMS AND CONDITIONS OF ANY WRITTEN AGREEMENT OR PURCHASE ORDER WHICH INCORPORATES OR RELATES TO THIS DRAWING.</p>	JOB NUMBER						ADDITIONAL INFO		
			THIRD ANGLE PROJECTION						Energy Services, Inc. 8303 SW Freeway #635 Houston, TX 77074		
			UNLESS OTHERWISE SPECIFIED, DIMENSIONS ARE IN INCHES. DO NOT SCALE DRAWING.						PRO ENERGY SERVICES 2031 ADAMS ROAD, SEDALIA, MISSOURI 65301 USA		
			TOLERANCES: DECIMALS .01 ± .03, FRACTIONAL 1/16" ± 1/32", ANGULAR ± 1°						TITLE: GUARENAS 1 - 69KV SUBSTATION ELECTRICAL LAYOUT SECTION A-A		
			NEXT ASSY.						DVG NO. ELE-002-02		
REV			DESCRIPTION	DRAWN	DATE	CHECKED BY	QA/QC	REVIEWER	UNIT TYPE	SCALE	SHEET OF
0			FIRST RELEASE								

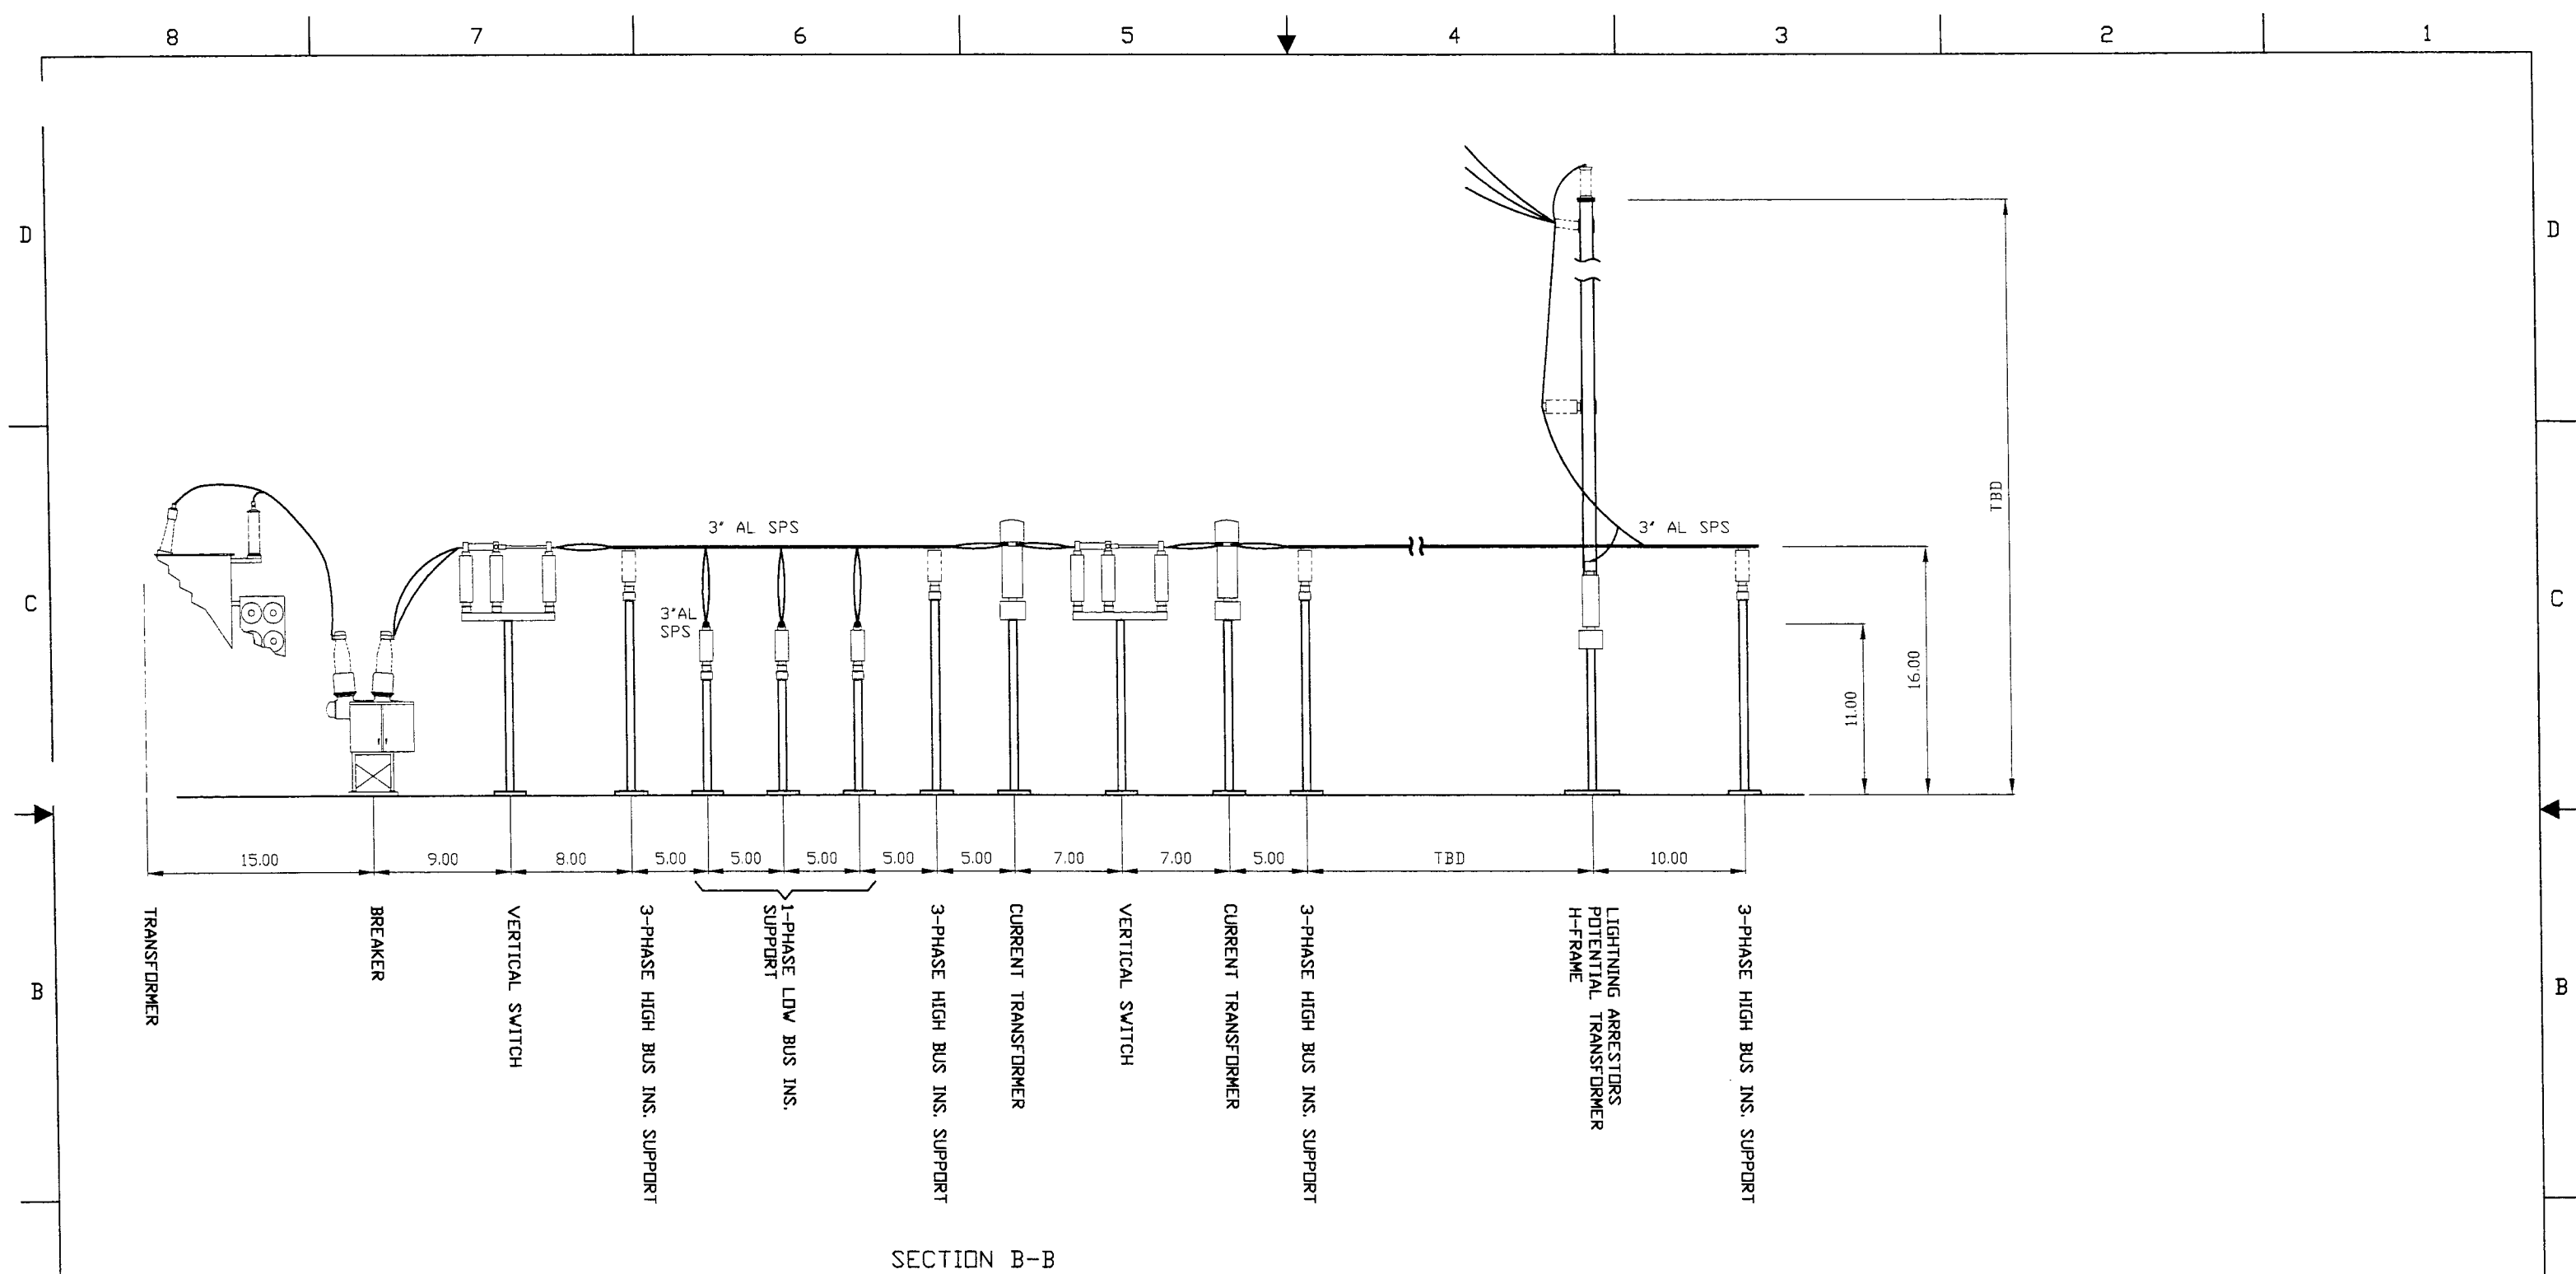

SECTION B-B


RESERVED FOR ENGINEER'S SEAL

CUSTOMER INFORMATION

© COPYRIGHT, 2008,
PRO ENERGY SERVICES
ALL RIGHTS RESERVED.
THIS DRAWING IS THE PROPRIETARY
AND/OR CONFIDENTIAL PROPERTY OF
PRO ENERGY SERVICES AND IS
LOANED IN STRICT CONFIDENCE
WITH THE UNDERSTANDING THAT IT
WILL NOT BE REPRODUCED NOR
USED FOR ANY PURPOSE EXCEPT
THAT FOR WHICH IT IS LOANED. IT
SHALL BE IMMEDIATELY RETURNED
ON DEMAND, AND IS SUBJECT TO
ALL OTHER TERMS AND CONDITIONS
OF ANY WRITTEN AGREEMENT OR
PURCHASE ORDER WHICH
INCORPORATES OR RELATES TO THIS
DRAWING.

REV	DESCRIPTION	DRAWN	DATE	CHECKED BY	QA/QC	REVIEWER
0	FIRST RELEASE					
REVISIONS						

JOB NUMBER	ADDITIONAL INFO
THIRD ANGLE PROJECTION	Energy Services, Inc. 2031 ADAMS ROAD, SEDALIA, MISSOURI 65301 USA 8303 SW Freeway #635 Houston, TX 77074
UNLESS OTHERWISE SPECIFIED DIMENSIONS ARE IN INCHES DO NOT SCALE DRAWING	PRO ENERGY SERVICES
TOLERANCES DECIMALS .001 ± .003 FRACTIONAL 1/16" ± 1/32" ANGULAR ± 1°	TITLE GUARENAS 1 - 69KV SUBSTATION ELECTRICAL LAYOUT SECTION B-B
NEXT ASSY.	DWG. NO. ELE-002-02
UNIT TYPE	SCALE
	SHEET OF

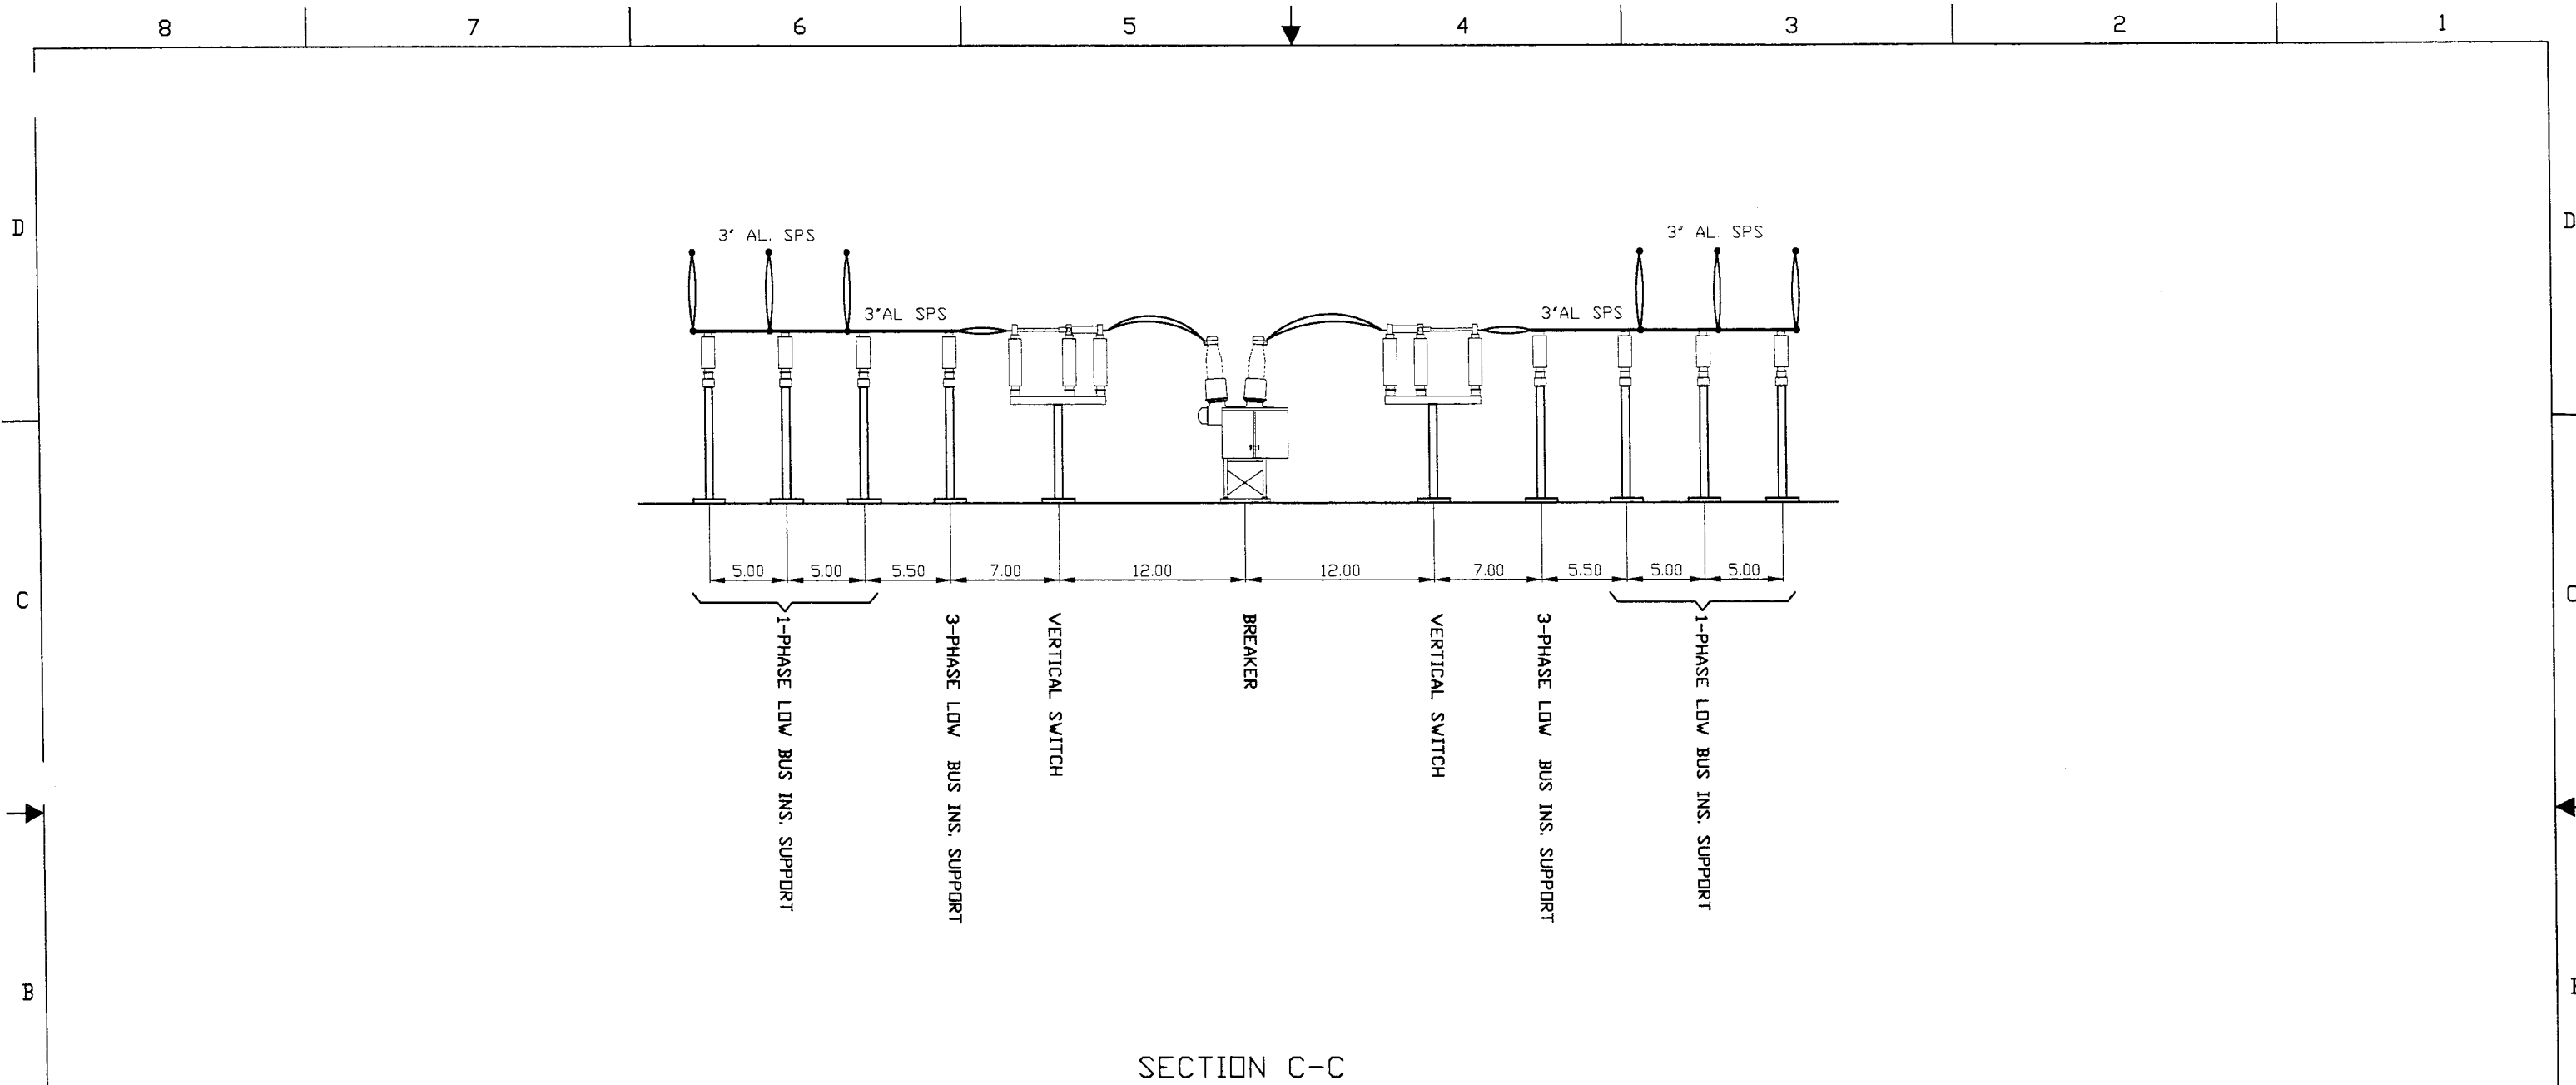

SECTION C-C

RESERVED FOR ENGINEER'S SEAL

CUSTOMER INFORMATION

© COPYRIGHT, 2008,
PRO ENERGY SERVICES
ALL RIGHTS RESERVED.
THIS DRAWING IS THE PROPRIETARY
AND/OR CONFIDENTIAL PROPERTY OF
PRO ENERGY SERVICES AND IS
LOANED IN STRICT CONFIDENCE
WITH THE UNDERSTANDING THAT IT
WILL NOT BE REPRODUCED NOR
USED FOR ANY PURPOSE EXCEPT
THAT FOR WHICH IT IS LOANED. IT
SHALL BE IMMEDIATELY RETURNED
ON DEMAND, AND IS SUBJECT TO
ALL OTHER TERMS AND CONDITIONS
OF ANY WRITTEN AGREEMENT OR
PURCHASE ORDER WHICH
INCORPORATES OR RELATES TO THIS
DRAWING.

REV	DESCRIPTION	DRAWN	DATE	CHECKED BY	QA/QC	REVIEWER
0	FIRST RELEASE					
REVISIONS						

JOB NUMBER	ADDL. INFO
THIRD ANGLE PROJECTION	Energy Services, Inc. Houston, TX 77074
UNLESS OTHERWISE SPECIFIED DIMENSIONS ARE IN INCHES DO NOT SCALE DRAWING	PRO ENERGY SERVICES 2031 ADAMS ROAD, SEDALIA, MISSOURI 65301 USA
DECIMALS JOK ± .03 JOCK ± .010	TOLERANCES FRACTIONAL ± 1/16"
ANGULAR ± 1°	TITLE GUARENAS 1 - 69KV SUBSTATION ELECTRICAL LAYOUT SECTION C-C
NEXT ASSY.	DWG. NO. ELE-002-02
UNIT TYPE	SCALE
	SHEET OF