


Section 11.0 Drawings


Please find on the following pages the following preliminary project drawings.

Overview Site Plan	10-001 Sh 1
General Arrangement Plot Plan	10-002 Sh 1
Process Flow Diagram	50-001 Sh 1
Process Flow Diagram	50-001 Sh 2
Process Flow Diagram	50-001 Sh 3
Process Flow Diagram	50-001 Sh 4
Generator One Line Diagram	60-001 Sh 1
Generator One Line Diagram	60-001 Sh 2
One Line Diagram	60-003 Sh 1
One Line Diagram	60-004 Sh 1
One Line Diagram	60-004 Sh 2
One Line Diagram	60-004 Sh 3
One Line Diagram	60-004 Sh 4

THIS DOCUMENT IS CONFIDENTIAL. IT IS DESIGNED AND INTENDED FOR EDC'S USE. THIS DOCUMENT IS FOR THE SOLE PURPOSE OF EVALUATING PROENERGY EPC SERVICES' PROPOSAL FOR THE FT8-3 SWIFTPAC POWER PROJECT.

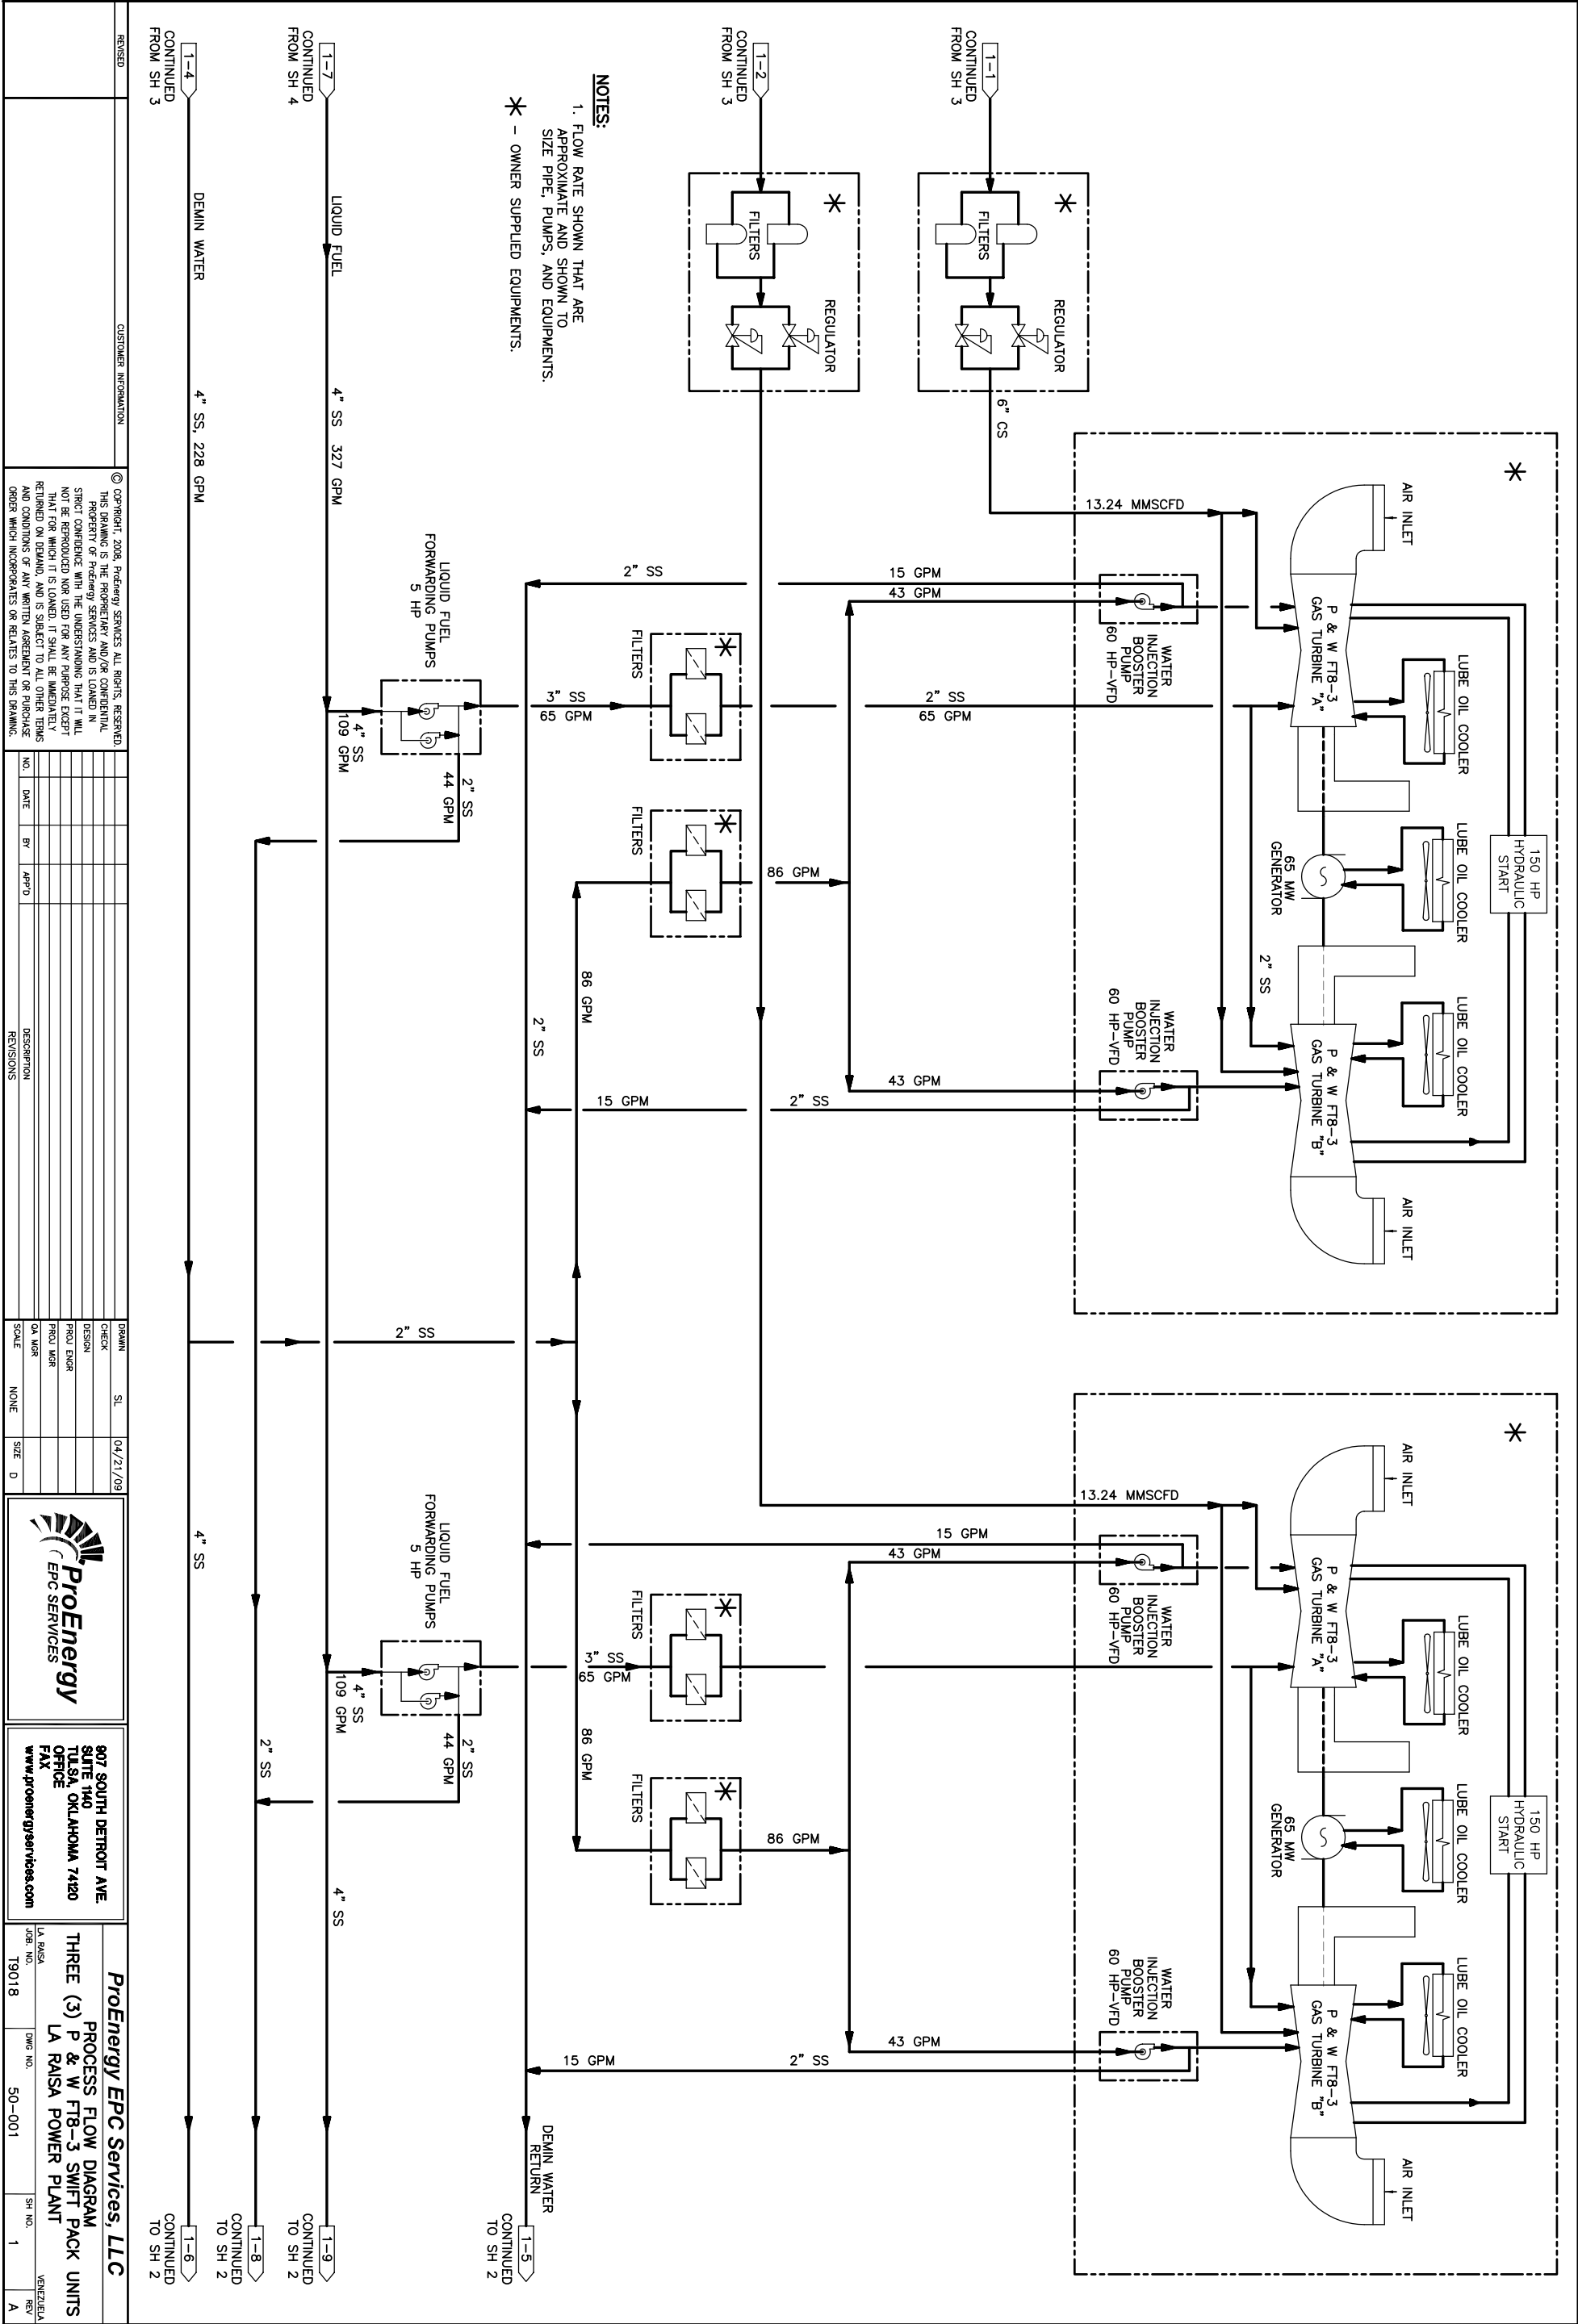


REVISED		CUSTOMER INFORMATION		© COPYRIGHT, 2008, ProEnergy Services, All Rights Reserved. THIS DRAWING IS THE PROPRIETARY AND/OR CONFIDENTIAL PROPERTY OF ProEnergy Services AND IS LOANED IN STRICT COMPLIANCE WITH THE UNDERSIGNED'S POLICY THAT IT ALL RIGHTS ARE RESERVED. NO PART OF THIS DRAWING IS TO BE REPRODUCED OR TRANSMITTED IN ANY FORM OR BY ANY MEANS, ELECTRONIC OR MECHANICAL, INCLUDING PHOTOCOPYING, RECORDING, OR BY ANY INFORMATION STORAGE AND RETRIEVAL SYSTEM, WITHOUT PERMISSION IN WRITING FROM THE UNDERSIGNED. IT SHALL BE IMMEDIATELY RETURNED ON DEMAND, AND IS SUBJECT TO ALL OTHER TERMS AND CONDITIONS OF ANY WRITTEN AGREEMENT OR PURCHASE ORDER WHICH INCORPORATES OR RELATES TO THIS DRAWING.					
		NO.	DATE	BY	APP'D	DESCRIPTION	SCALE	SIZE	D
						REVISIONS	NONE		
<div><div>ProEnergy EPC SERVICES</div></div> <div>907 SOUTH DETROIT AVE SUITE 1040 TULSA, OKLAHOMA 74120 OFFICE FAX www.proenergyservices.com</div>									
ProEnergy EPC Services, LLC									
THREE (3) P & W FTH-3 SWIFT PACK UNITS LA RAISA POWER PLANT									
LA RAISA		DWG NO.		50-001		SH NO.		1	
JOB NO.		19018				VENEZUELA		REV A	

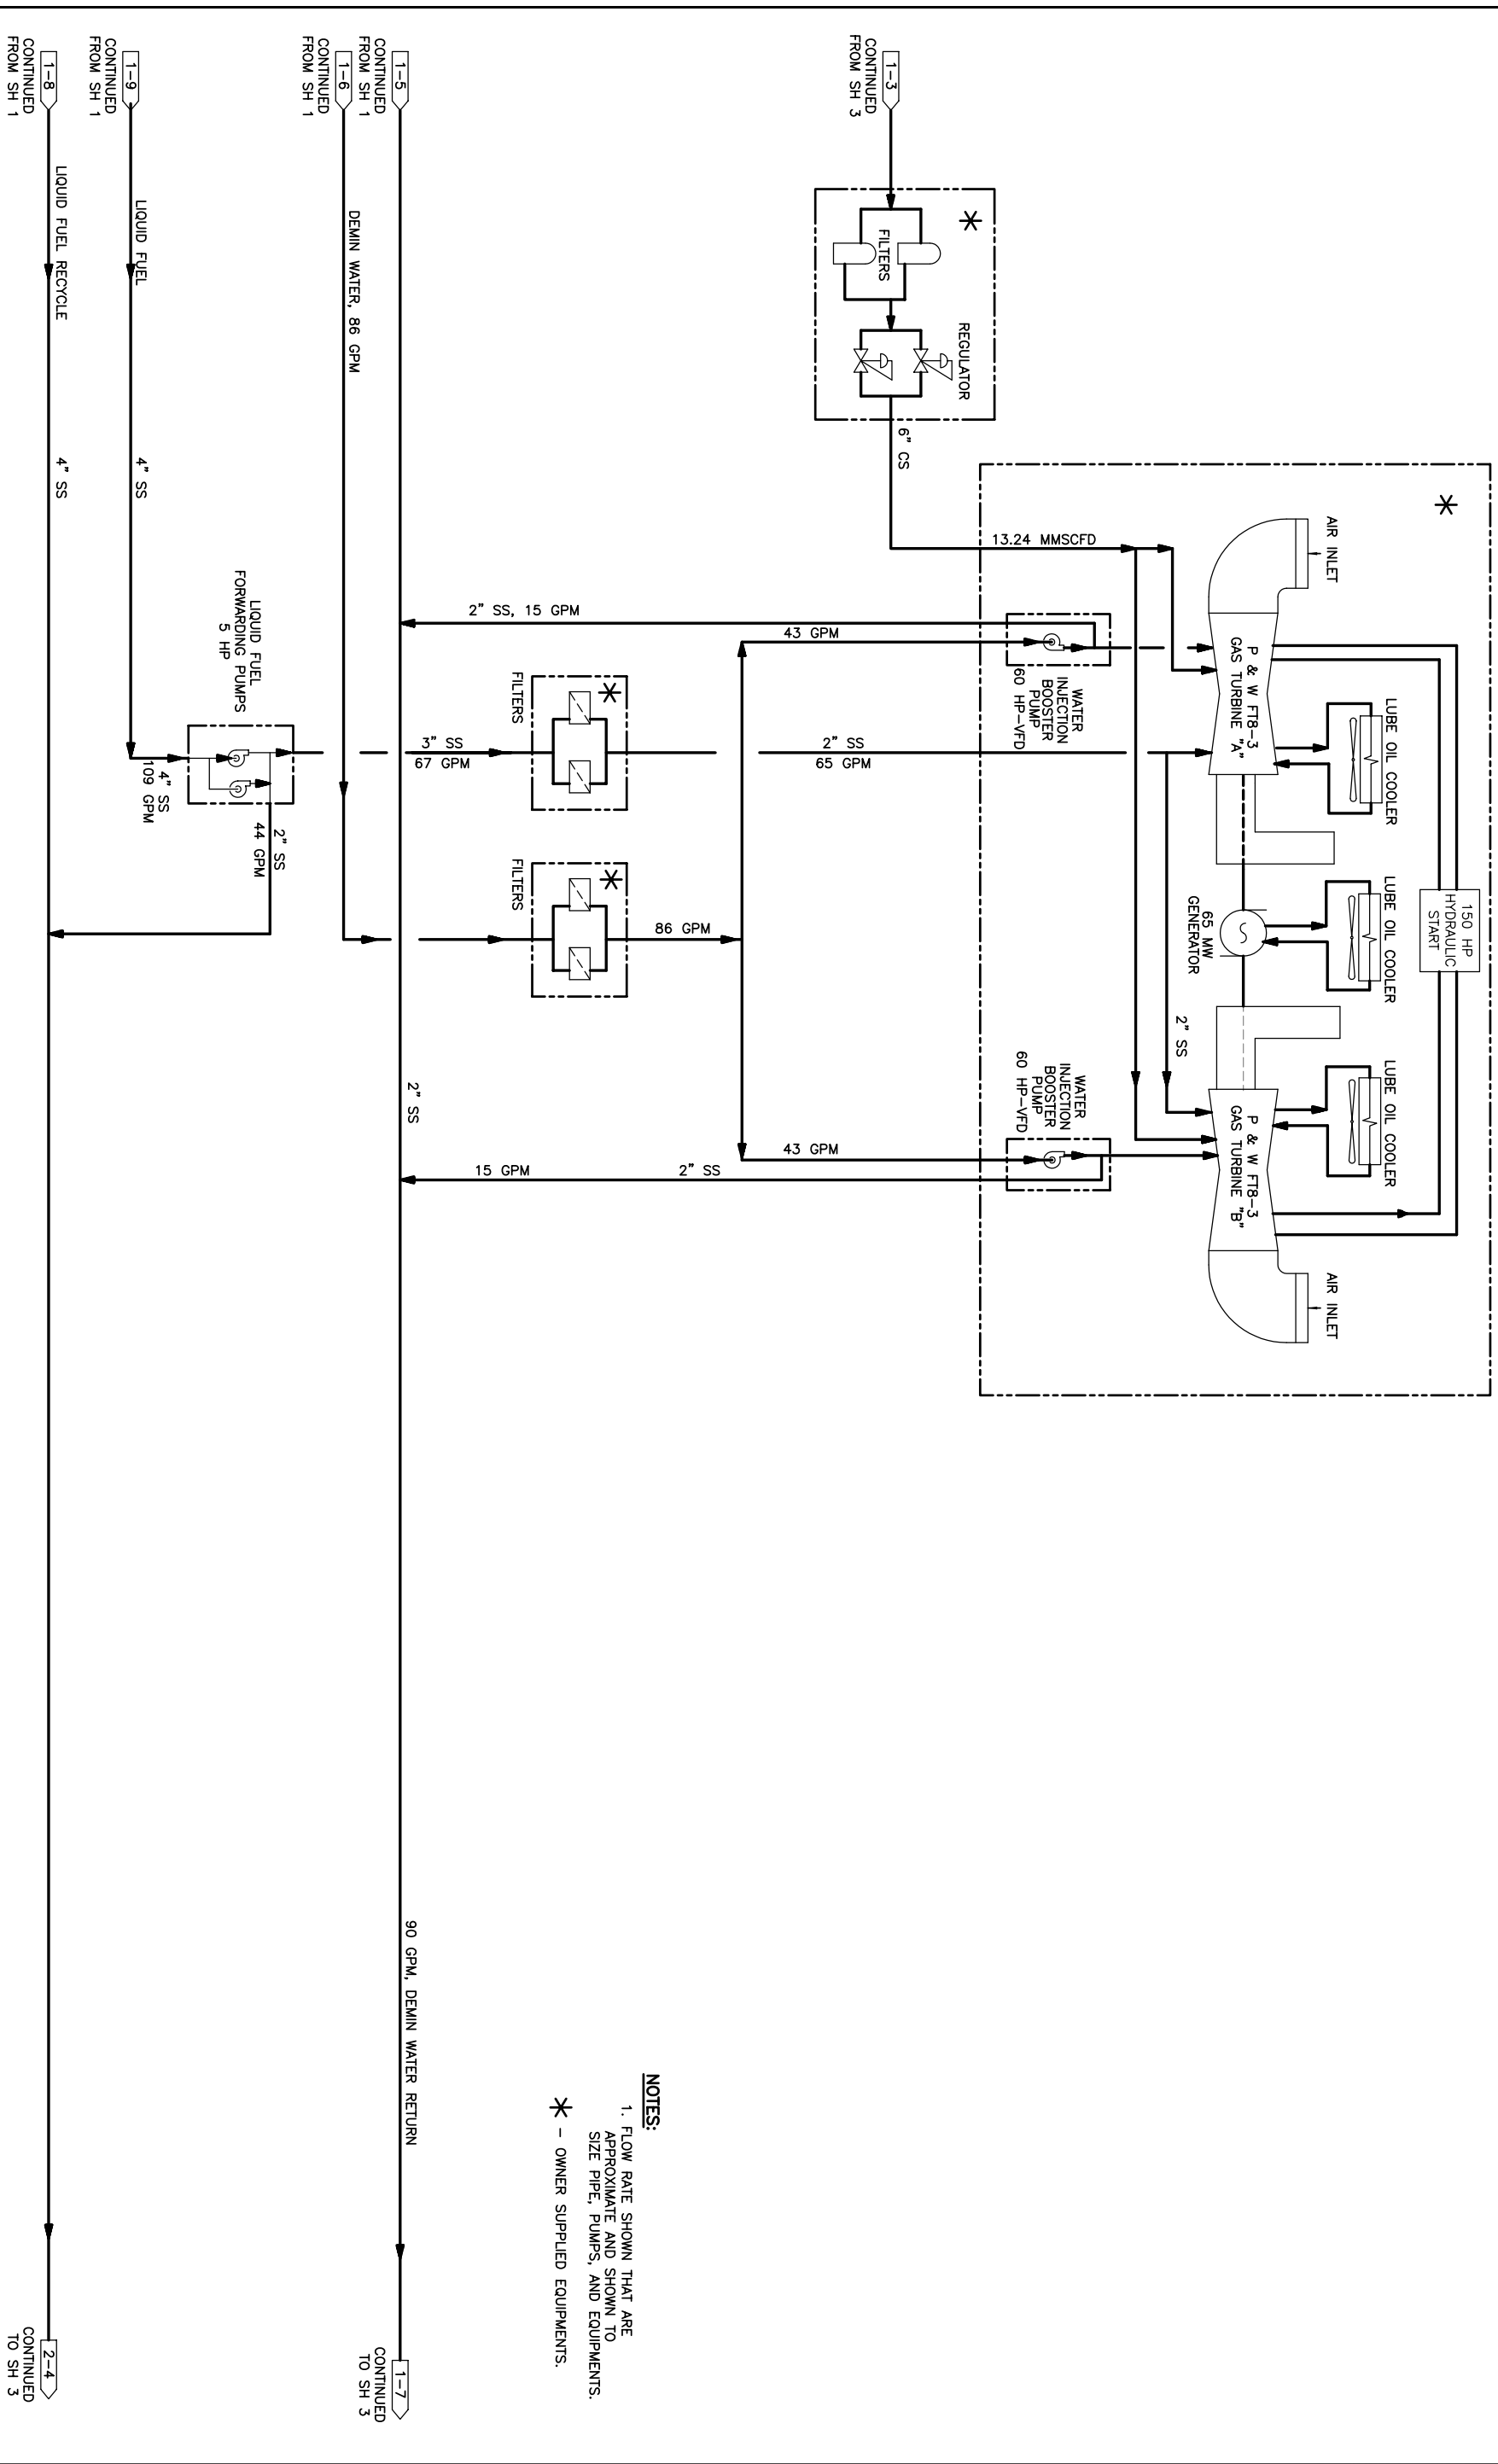



NOTES:

1. FLOW RATE SHOWN THAT ARE APPROXIMATE AND SHOWN TO SIZE PIPE, PUMPS, AND EQUIPMENTS.

* - OWNER SUPPLIED EQUIPMENTS

CUSTOMER INFORMATION					
REVISED					
<p>© COPYRIGHT 2008. Preliminary SERVICES. ALL RIGHTS RESERVED. THIS DRAWING IS THE PROPRIETARY AND/OR CONFIDENTIAL PROPERTY OF ProEnergy SERVICES AND IS LOANED IN STRICT CONFIDENCE WITH THE UNDERSTANDING THAT IT WILL NOT BE REPRODUCED NOR USED FOR ANY PURPOSE EXCEPT THAT AUTHORIZED BY PROENERGY SERVICES. IF THIS DRAWING IS RETURNED ON DEMAND, AND IS SUBJECT TO ALL OTHER TERMS AND CONDITIONS OF ANY WRITTEN AGREEMENT OR PURCHASE ORDER WHICH INCORPORATES OR RELATES TO THIS DRAWING.</p>					
		NO.	DATE	BY	APPROD.
		REVISIONS			
CHECK	DRAWN	SL	04/21/09		
DESIGN					
PROJECT ENGINEER					
PROJECT MANAGER					
QA/MGR					
SIZE	D				
SCALE	NONE				
<div><p>ProEnergy EPC SERVICES</p></div>					
907 SOUTH DETROIT AVE. SUITE 1040 TULSA, OKLAHOMA 74120 FAX www.proenergyservices.com					
<p>ProEnergy EPC Services, LLC</p> <p>PROCESS FLOW DIAGRAM THREE (3) P & W FTB--3 SWIFT PACK UNITS LA RAISA POWER PLANT</p>					
JOB NO.	DWG NO.	SH NO.	REV		
T9018	50--001	2	A	VENZUELA	

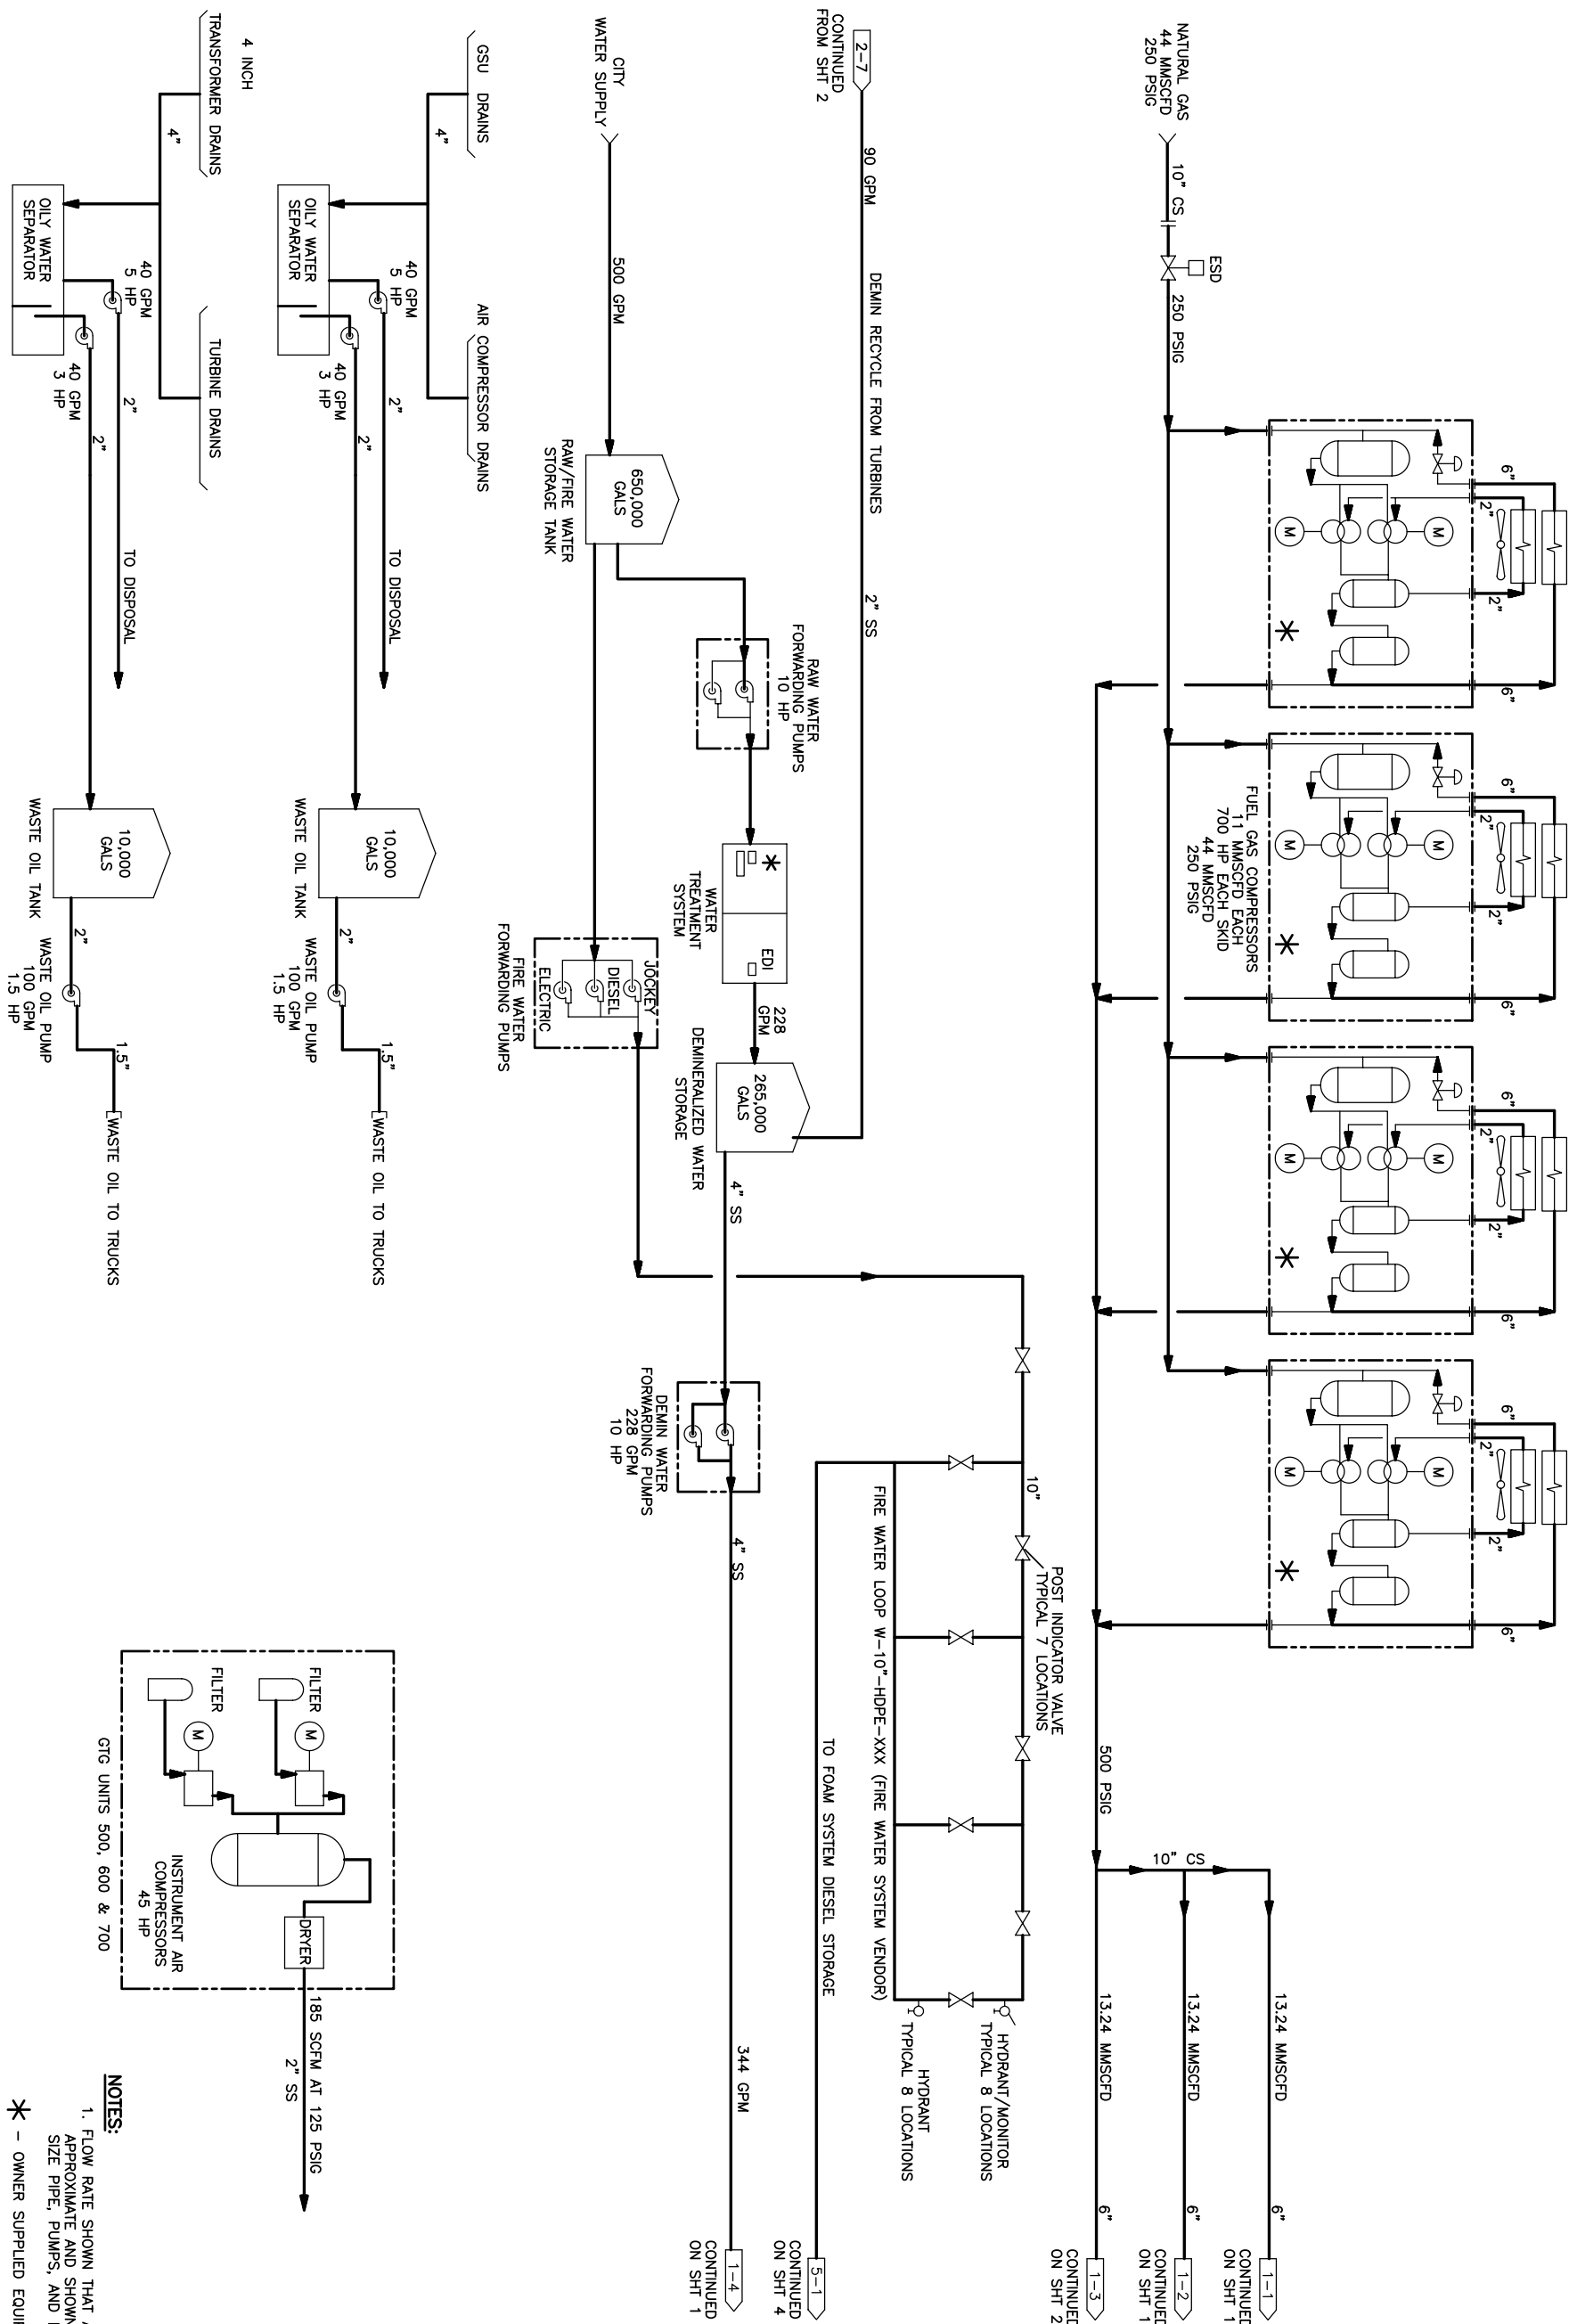
[illegible]

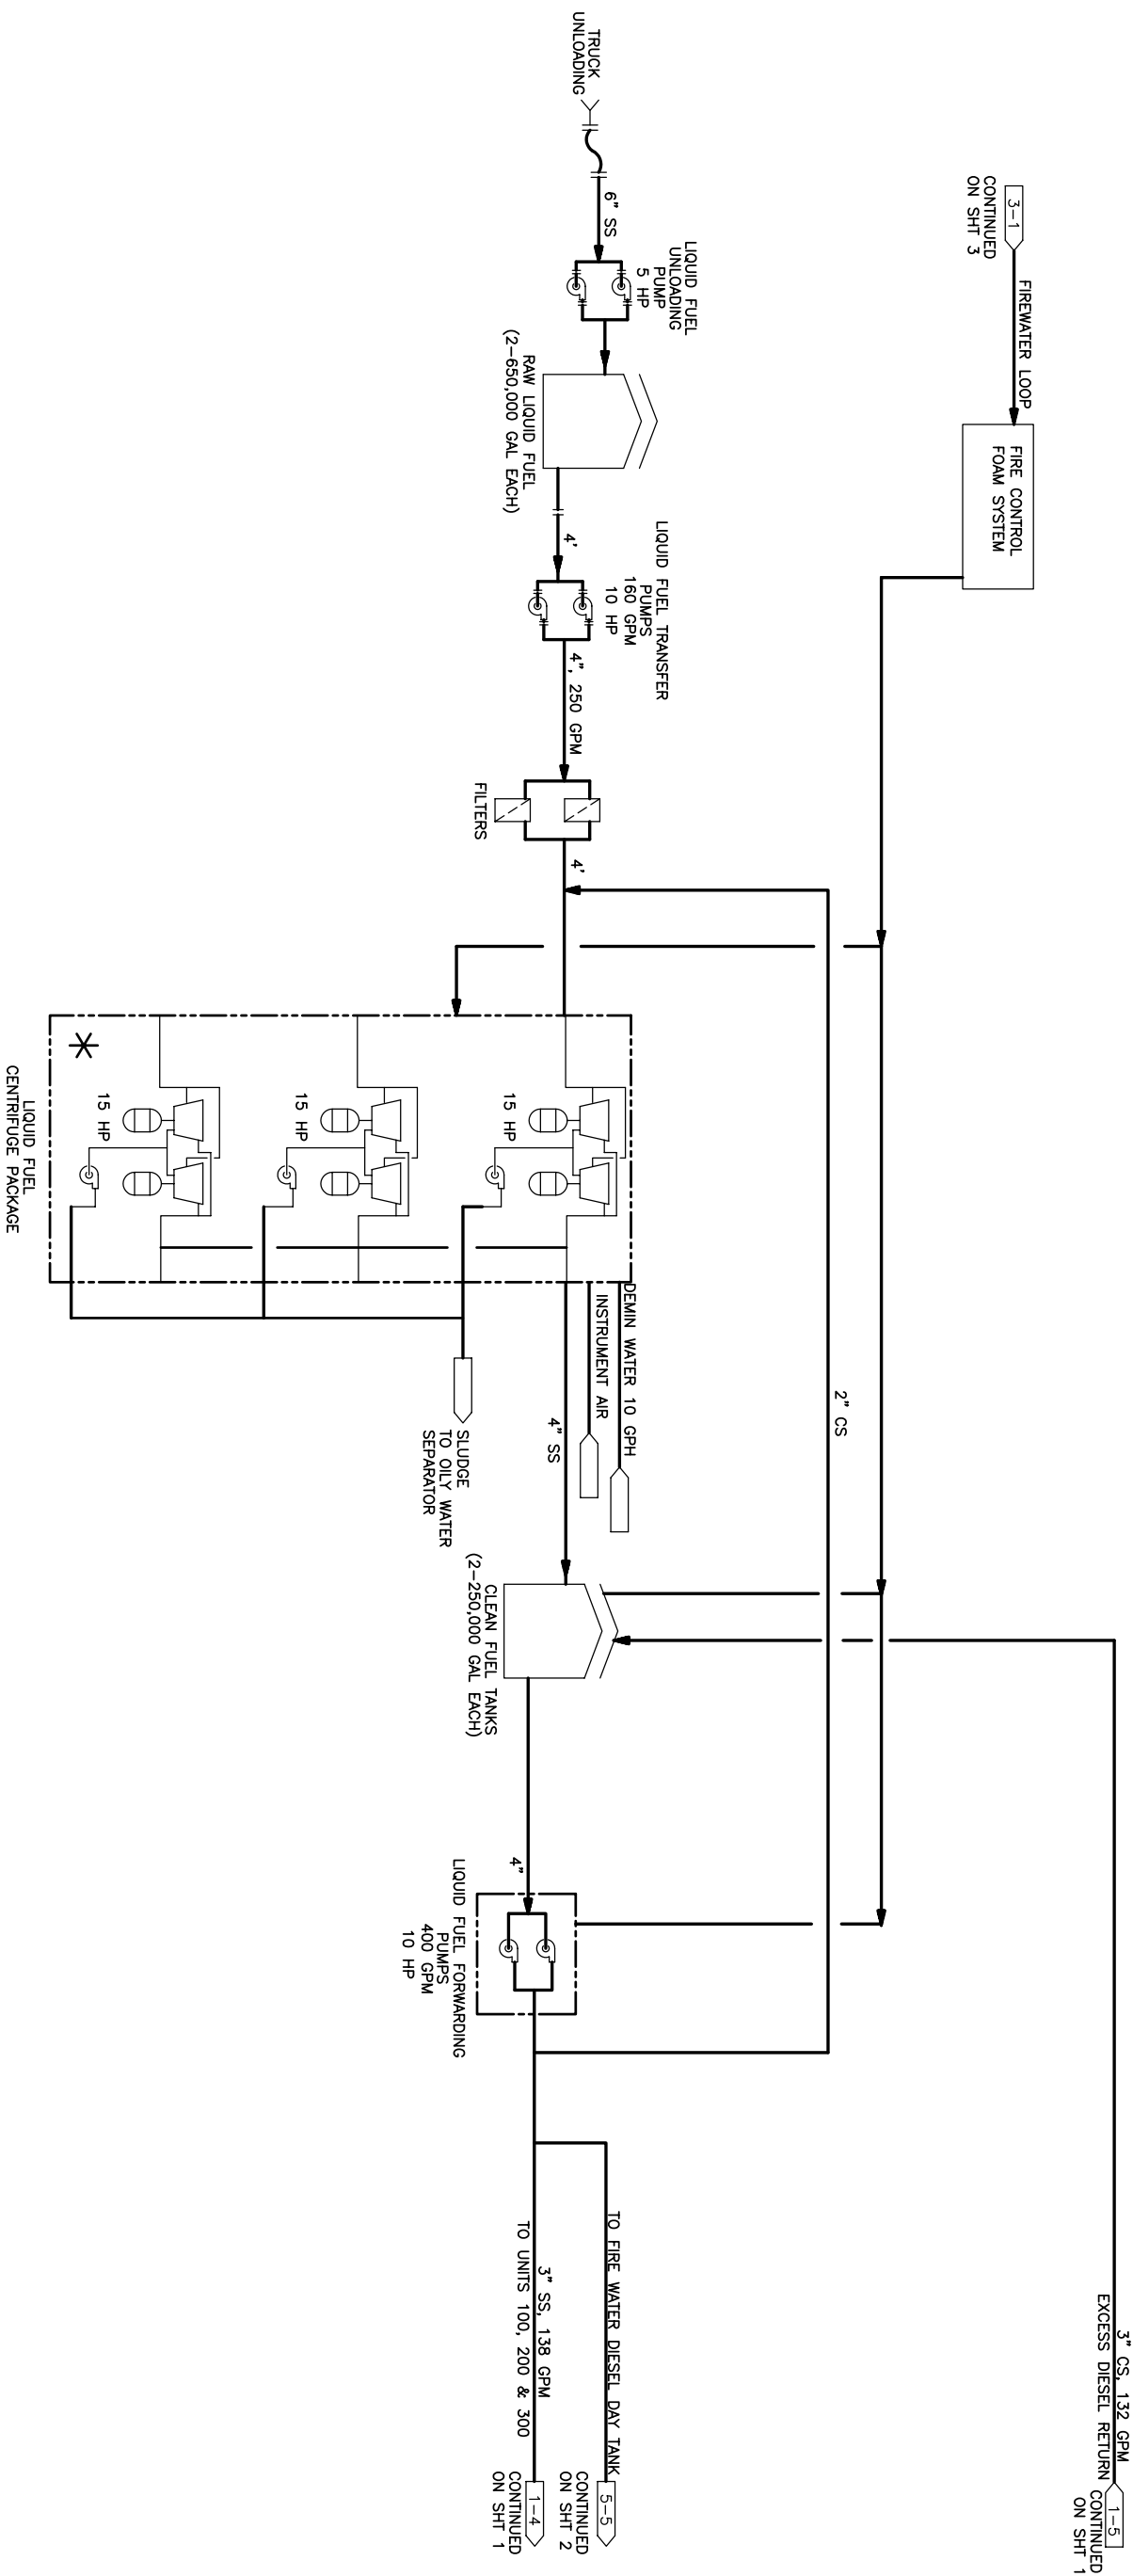


* - SUPPLIED BY OWNER.

NOTES:

1. FLOW RATE SHOWN THAT ARE APPROXIMATE AND SHOWN TO SIZE PIPE, PUMPS, AND EQUIPMENTS.

CUSTOMER INFORMATION					
REVISED					
<p>© COPYRIGHT 2008. Preliminary SERVICES. ALL RIGHTS RESERVED. THIS DRAWING IS THE PROPRIETARY AND/OR CONFIDENTIAL PROPERTY OF ProEnergy SERVICES AND IS LOANED IN STRICT CONFIDENCE WITH THE UNDERSTANDING THAT IT WILL NOT BE REPRODUCED NOR USED FOR ANY PURPOSE EXCEPT THAT AUTHORIZED BY PROENERGY SERVICES. THIS DOCUMENT IS NOT TO BE COPIED OR REPRODUCED WITHOUT PERMISSION RETURNED ON DEMAND, AND IS SUBJECT TO ALL OTHER TERMS AND CONDITIONS OF ANY WRITTEN AGREEMENT OR PURCHASE ORDER WHICH INCORPORATES OR RELATES TO THIS DRAWING.</p>					
		NO.		DATE	
		BY		APPROD	
		DESCRIPTION			
		REVISIONS			
		CHECK		SL	
		DESIGN		04/21/09	
		PROJ ENGR			
		PROJ MGR			
		QA MGR			
		SCALE		SIZE D	
		NONE			
<div><p>ProEnergy EPC SERVICES</p></div>					
907 SOUTH DETROIT AVE SUITE 1040 TULSA, OKLAHOMA 74120 FAX www.proenergyservices.com					
<p>ProEnergy EPC Services, LLC</p> <p>PROCESS FLOW DIAGRAM THREE (3) P & W TIG-3 SWIFT PACK UNITS LA RAISA POWER PLANT</p>					
JOB NO.		DWG NO.		SH NO.	
79018		50--001		4	
REV				VENZUELA	
				A	

* – SUPPLIED BY OWNER.

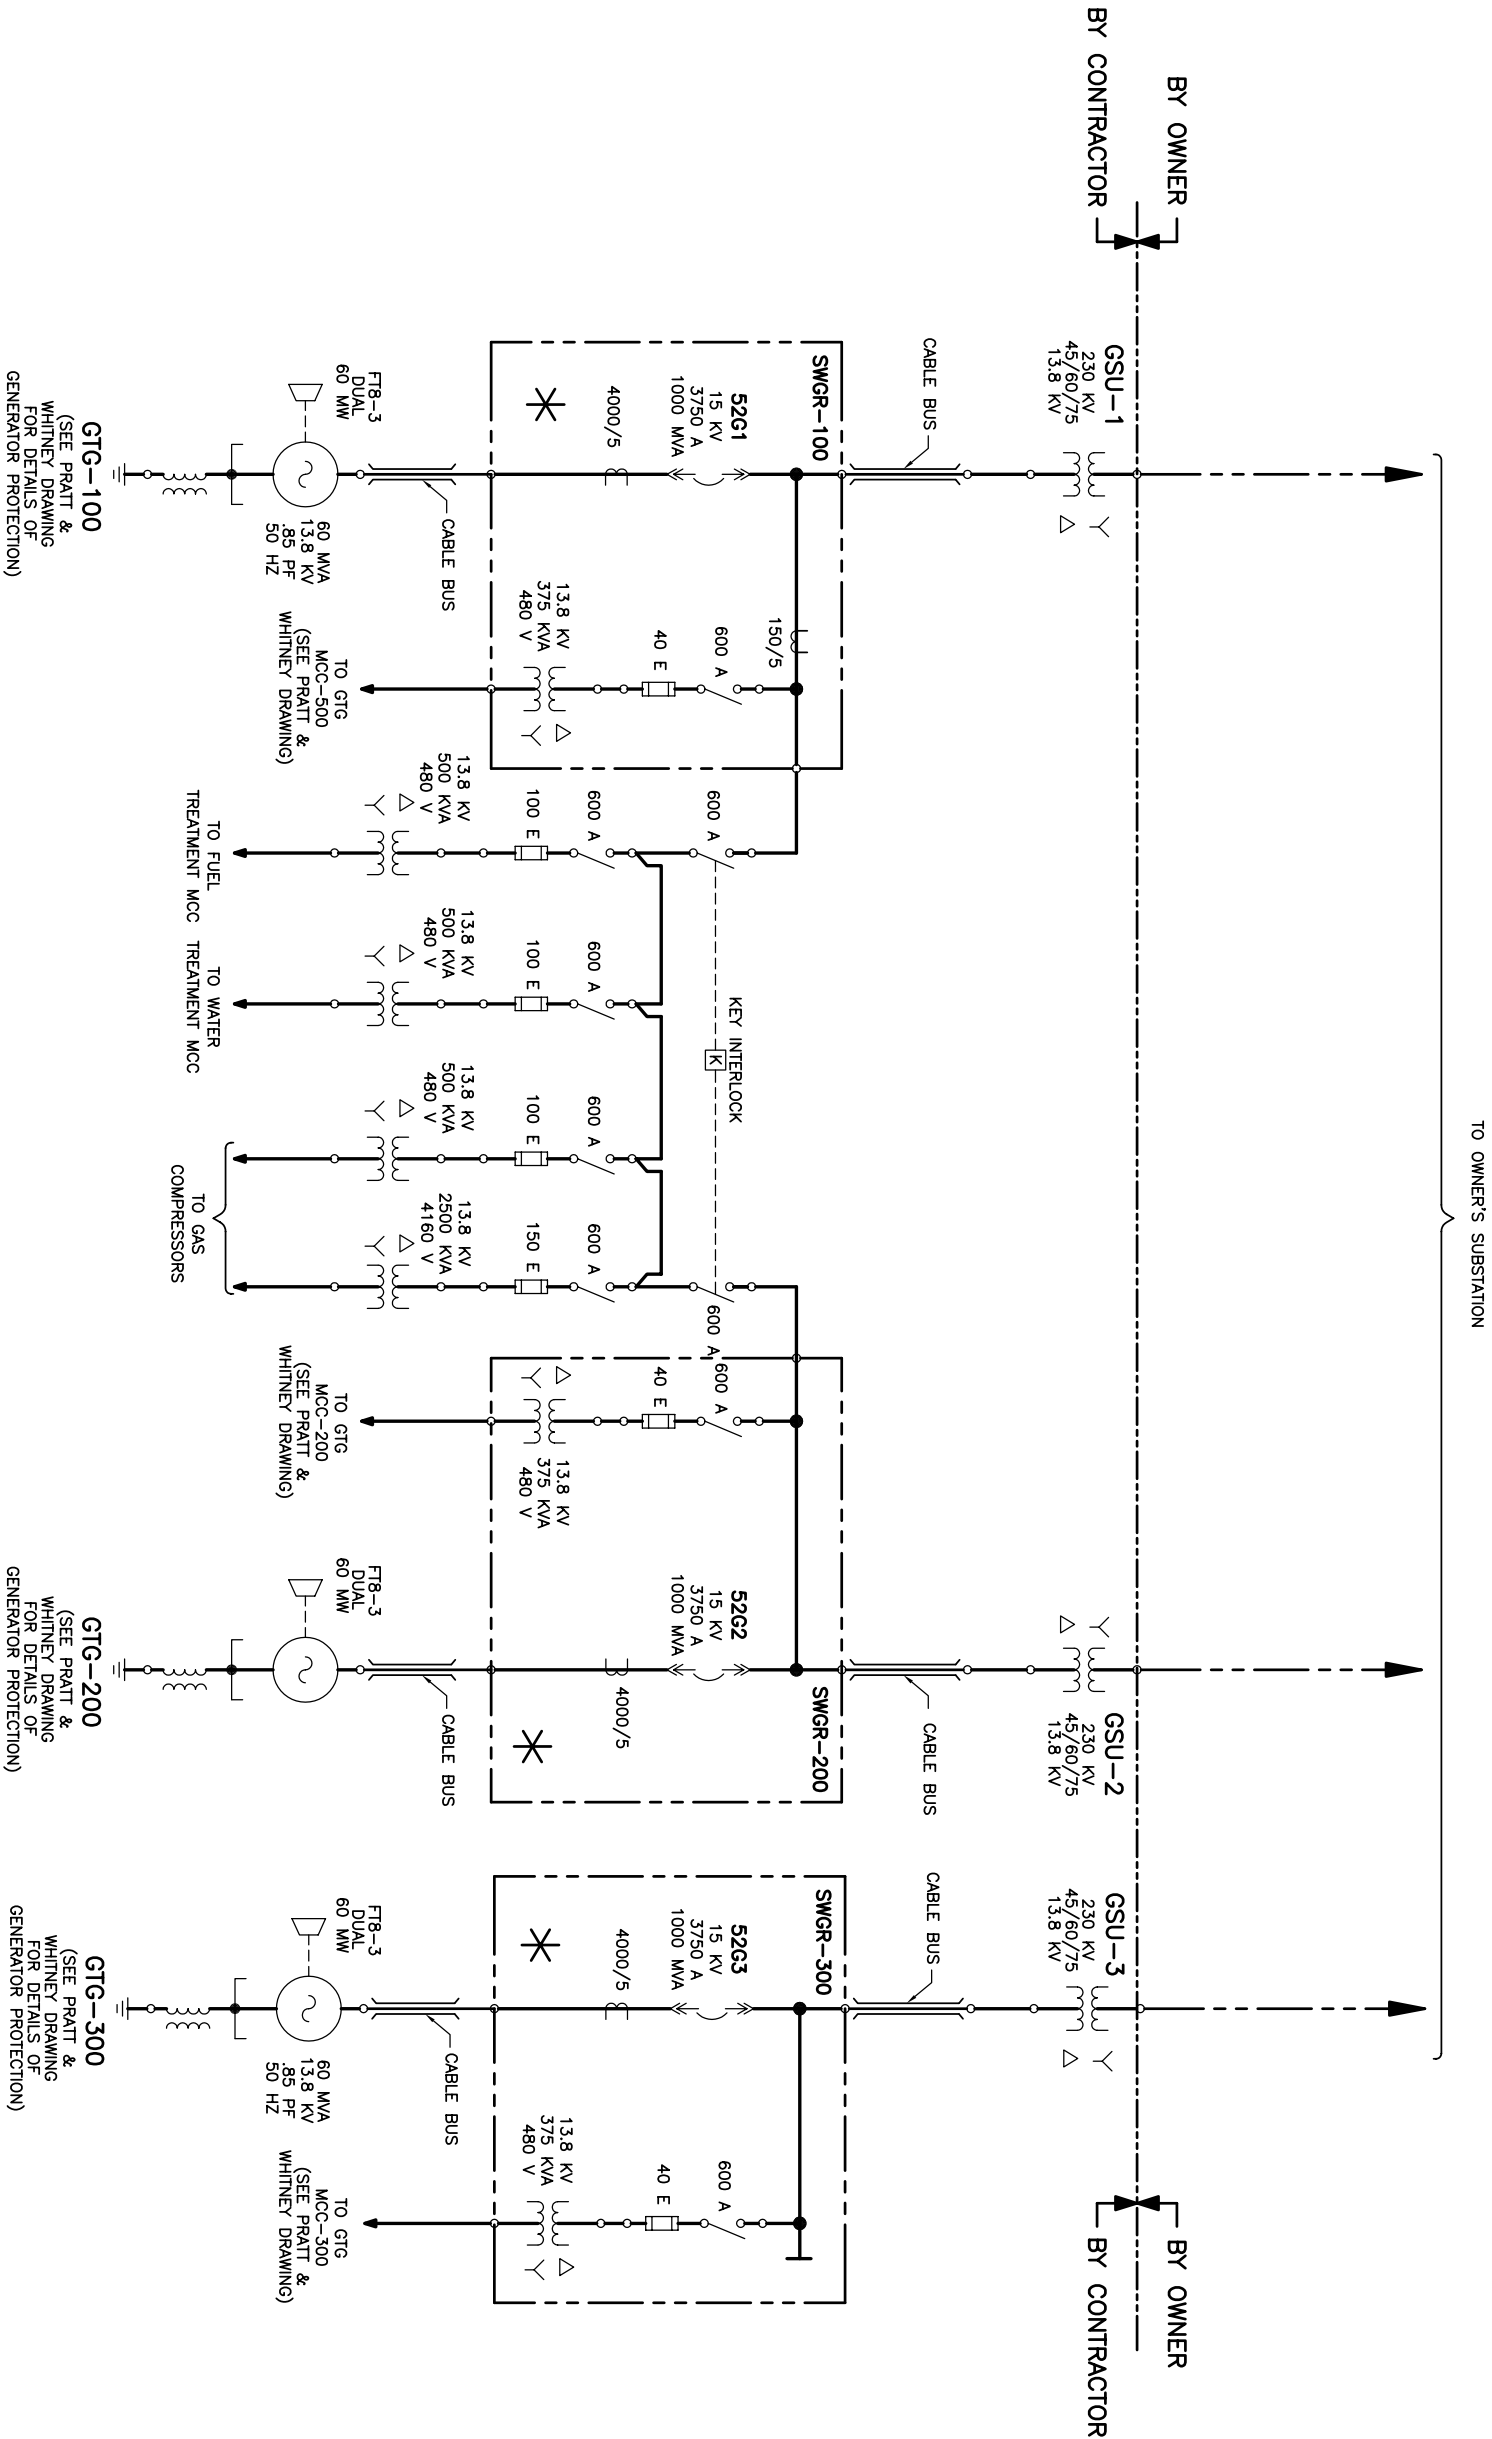

CUSTOMER INFORMATION										REVISED	
© COPYRIGHT, 2008, ProEnergy SERVICES. ALL RIGHTS RESERVED. THIS DRAWING IS THE PROPRIETARY AND/OR CONFIDENTIAL PROPERTY OF ProEnergy SERVICES AND IS LOANED IN STRICT CONFIDENCE WITH THE UNDERSTANDING THAT IT WILL NOT BE REPRODUCED NOR USED FOR ANY PURPOSE EXCEPT THAT FOR WHICH IT IS LOANED. IT SHALL BE IMMEDIATELY RETURNED ON DEMAND, AND IS SUBJECT TO ALL OTHER TERMS AND CONDITIONS OF ANY WRITTEN AGREEMENT OR PURCHASE ORDER WHICH INCORPORATES OR RELATES TO THIS DRAWING.											
NO.		DATE		BY		APP'D		DESCRIPTION		REVISIONS	