


TO OWNER'S SUBSTATION
(BY OTHERS)

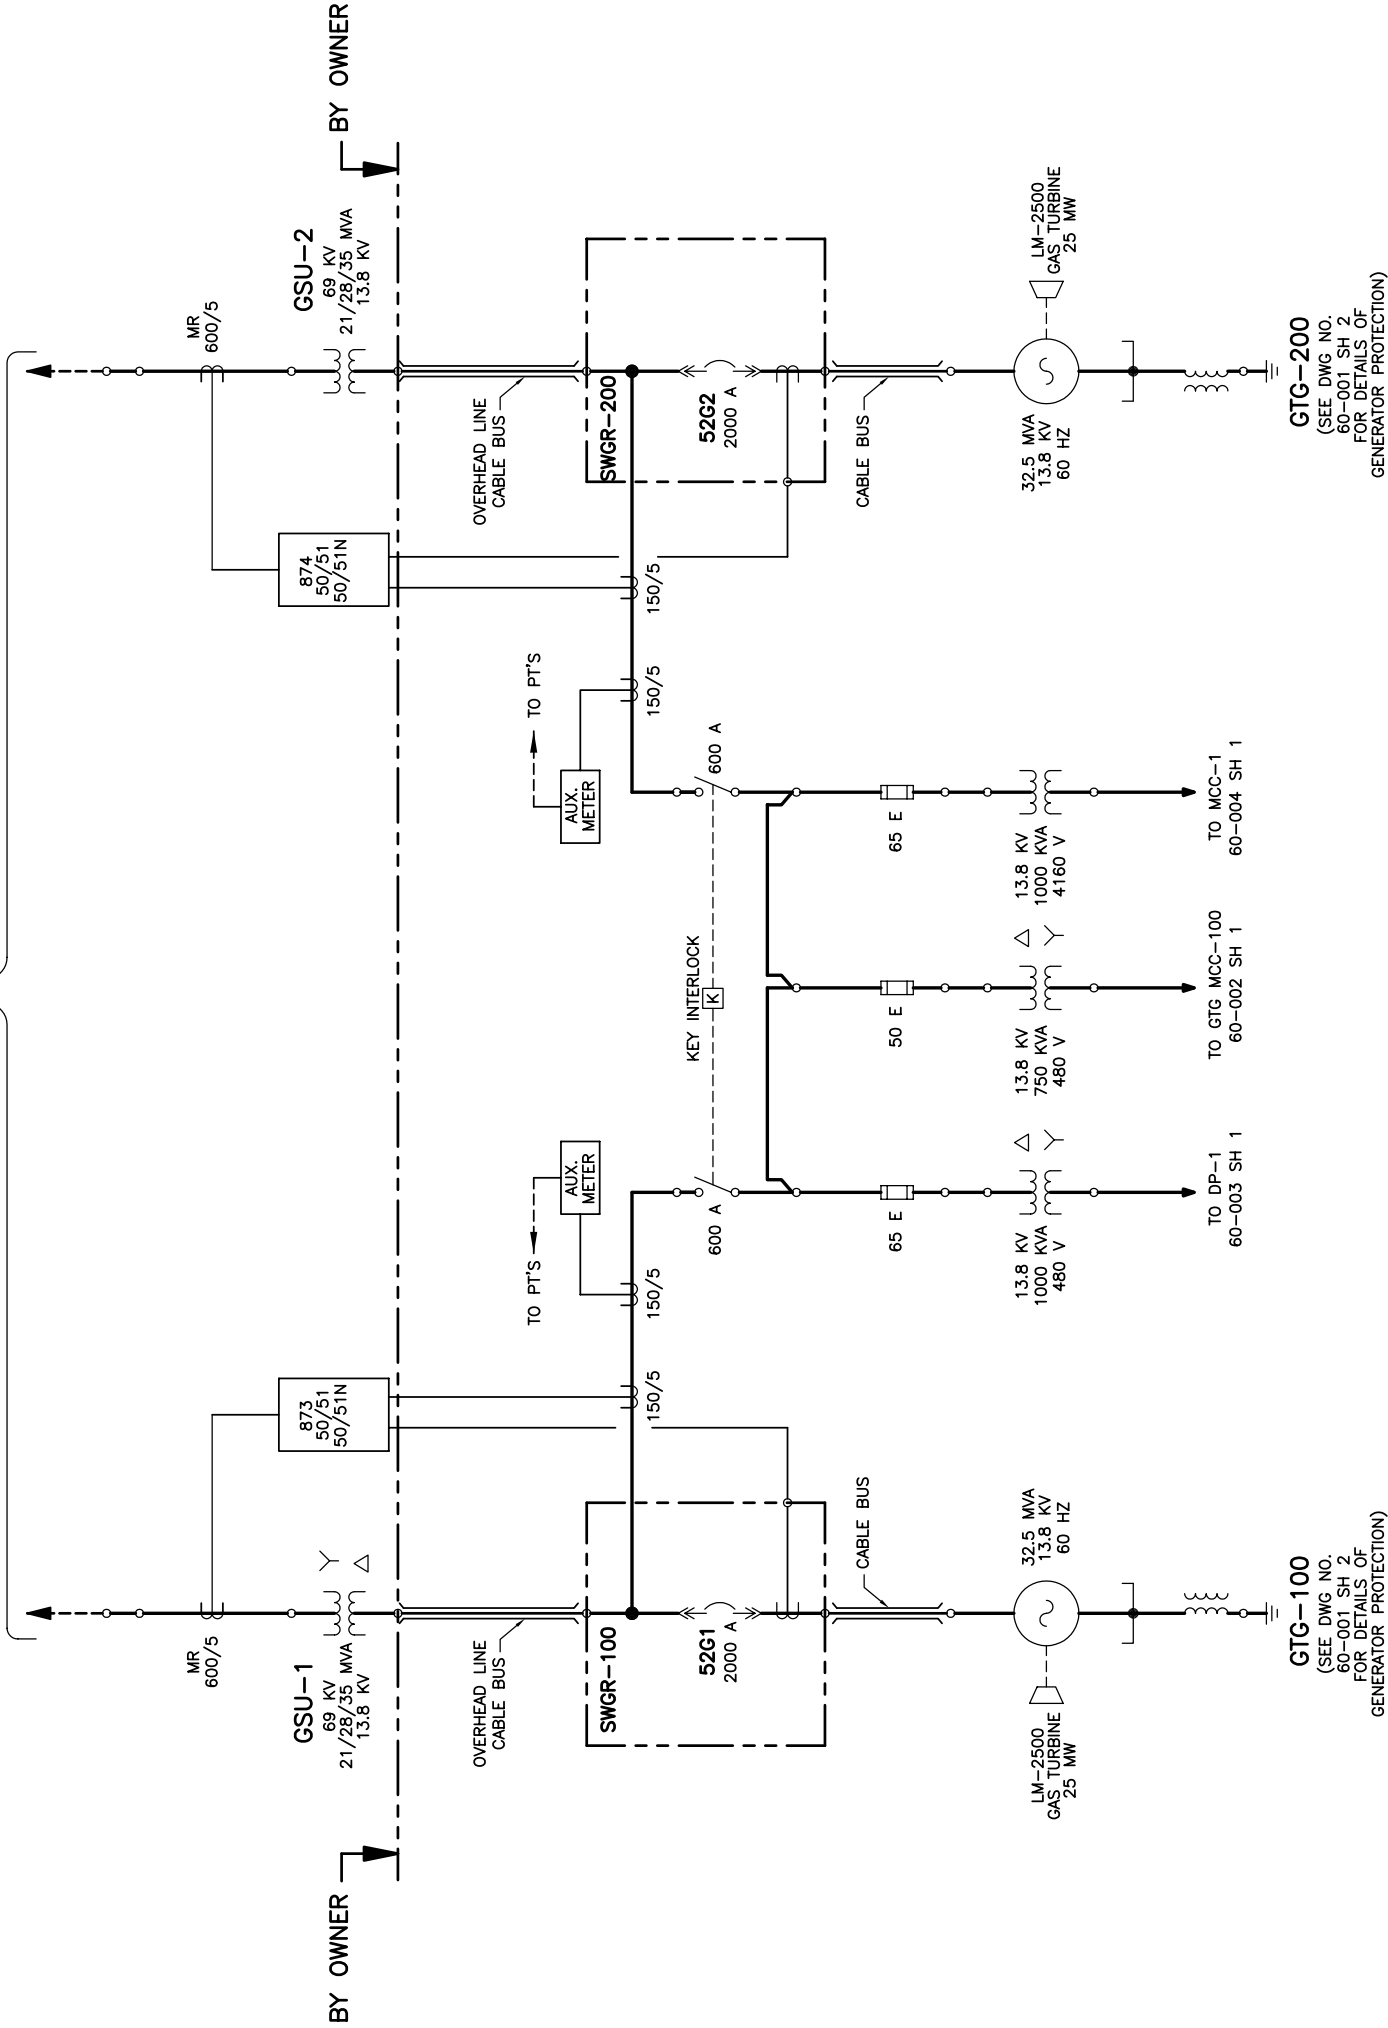

REVISED		CUSTOMER INFORMATION									
		© COPYRIGHT, 2008, ProEnergy SERVICES. ALL RIGHTS RESERVED. THIS DRAWING IS THE PROPERTY OF ProEnergy SERVICES AND IS LOANED IN STRICT CONFIDENCE WITH THE UNDERSTANDING THAT IT WILL NOT BE REPRODUCED NOR USED FOR ANY PURPOSE EXCEPT THAT FOR WHICH IT IS LOANED. IT SHALL BE IMMEDIATELY RETURNED ON DEMAND, AND IS SUBJECT TO ALL OTHER TERMS AND CONDITIONS OF ANY WRITTEN AGREEMENT OR PURCHASE ORDER WHICH INCORPORATES OR RELATES TO THIS DRAWING.									
		ProEnergy EPC SERVICES									
		807 SOUTH DETROIT AVE SUITE 1140 TULSA, OKLAHOMA 74120 OFFICE FAX www.proenergyservices.com									
		ProEnergy EPC Services, LLC									
		ONE LINE DIAGRAM TWO (2) LM-2500 GENERATOR UNITS TACOA POWER PLANT									
		TACOA JOB NO. T9003-A & B		DWG NO. 60-001		SH NO. 1		REV A		VENEZUELA	