
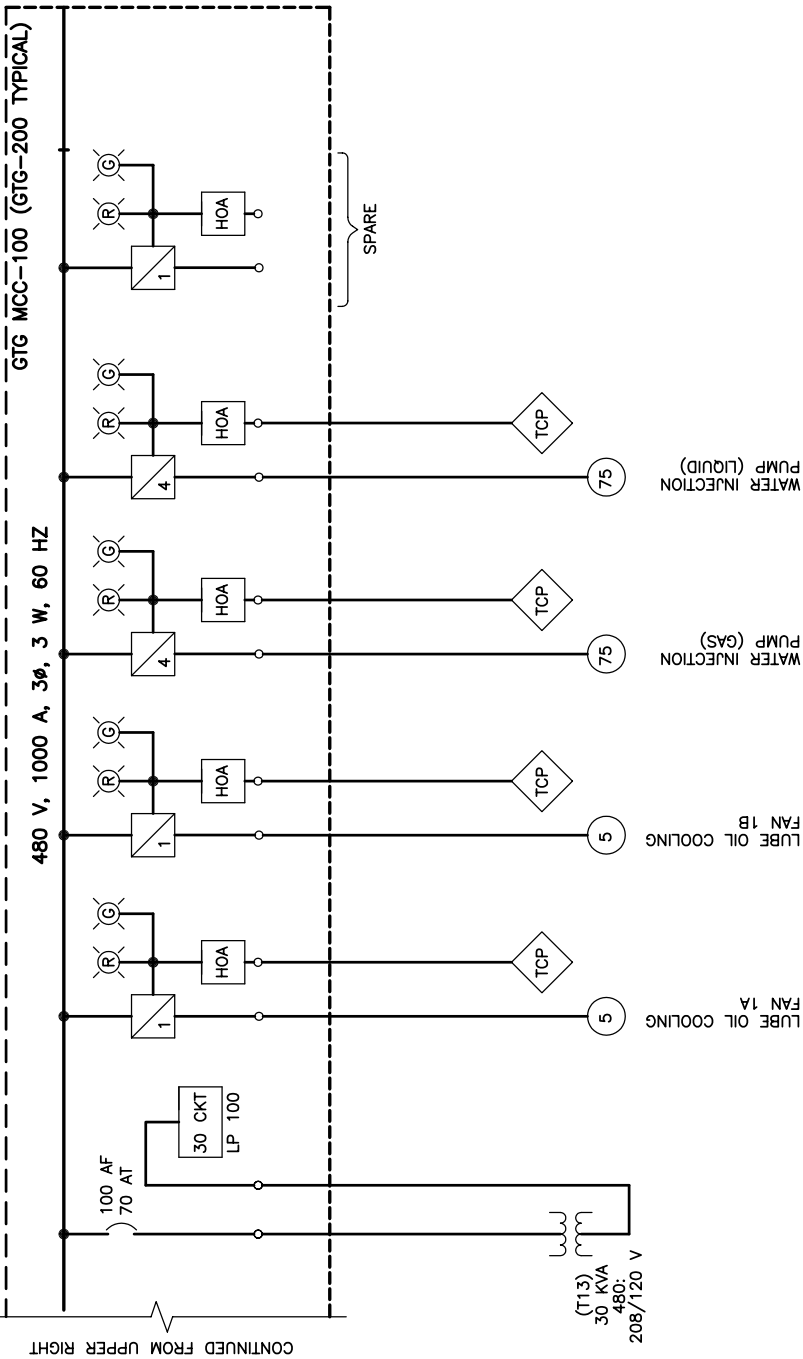
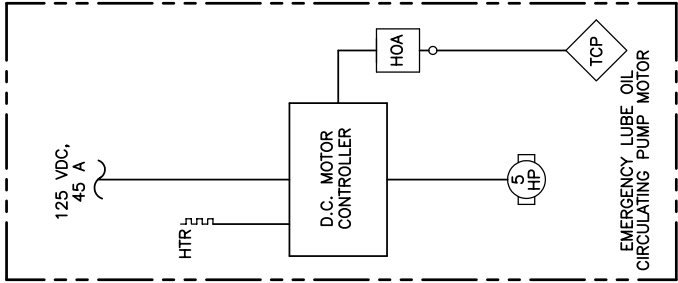


60-001 INCOMING POWER  
SH 1 FOR GTG MCC-100  
60-003 INCOMING POWER  
SH 1 FOR GTG MCC-200

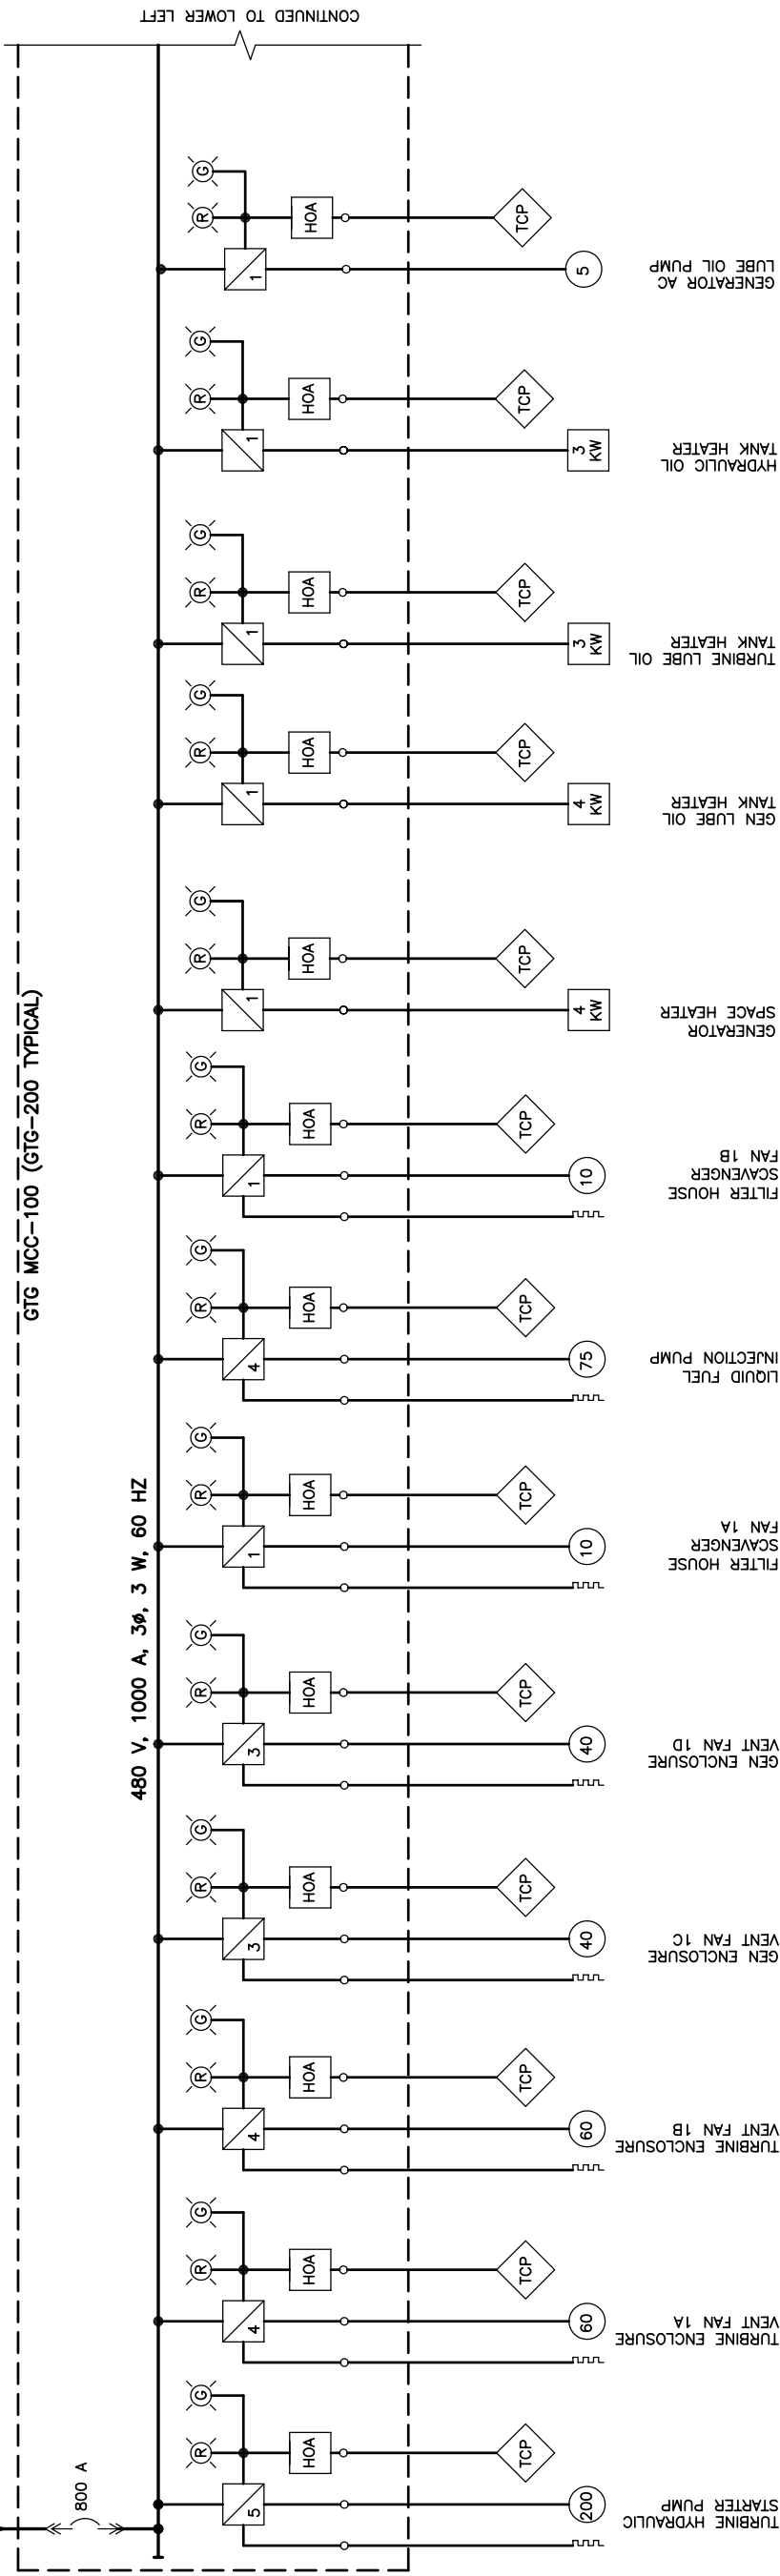

## TYPICAL FOR TWO (2) UNITS

REVISED		CUSTOMER INFORMATION										DRAWN				SL				04/23/09				ProEnergy EPC Services, LLC			
												CHECK												ONE LINE DIAGRAM			
												DESIGN												LM-2500 UNIT, 480 V GTG MCC-100			
												PROJ ENGR												TACOA POWER PLANT			
												QA MGR												TACOA			
												DATE				BY				APPRO				JOB NO.			
												NO.												T9003-A & B			
												DESCRIPTION				SCALE				NONE				DWG NO.			
												REVISIONS												60-002			
																								SH NO.			
																								1			
																								A			